

KEYNOTES

- 1  
TWENTY (20) NEW 12" WIDE-2 TIER METAL LOCKERS.  
VERIFY LOCATION IN ROOM. PROVIDE A 4"x14" CONCRETE  
BASE AND RUBBER BASE.
- 2  
VERIFY LOCATION OF ELECTRICAL PANELS
- 3  
PLASTIC LAMINATE CASEWORK AND COUNTERTOPS WITH 4" BACKSPASH
- 4  
REFRIGERATOR BY OWNER
- 5  
INSULATED TRAP AND HOT WATER LINE WRAP

PLUMBING FIXTURE KEYNOTES


- P1  
WALL MOUNTED FLUSH VALVE WATER CLOSET PER PLUMBING  
MOUNTED AT ACCESSIBLE HEIGHT PER AC-XXX
- P2  
WALL MOUNTED LAVATORY PER PLUMBING  
MOUNTED AT ACCESSIBLE HEIGHT PER AC-XXX
- P3  
STAINLESS STEEL KITCHEN SINK WITH ACCESSIBLE FAUCET  
PER PLUMBING

LEGEND


- 2-HOUR RATED METAL STUD WALL TO  
UNDERSIDE OF ROOF STRUCTURE
- NON-RATED METAL STUD PARTITION WALL
- ACCESS FLOOR PER DETAIL 5/AD1.2  
AND SPECIFICATIONS
- 101

WALL TYPE SYMBOL, SEE AD1.2



INT. ELEVATIONS-BREAK RM 204 SCALE: 3/8"=1'-0" 4 (E) INSTR. SHOP 108 SCALE: 3/8"=1'-0" 3

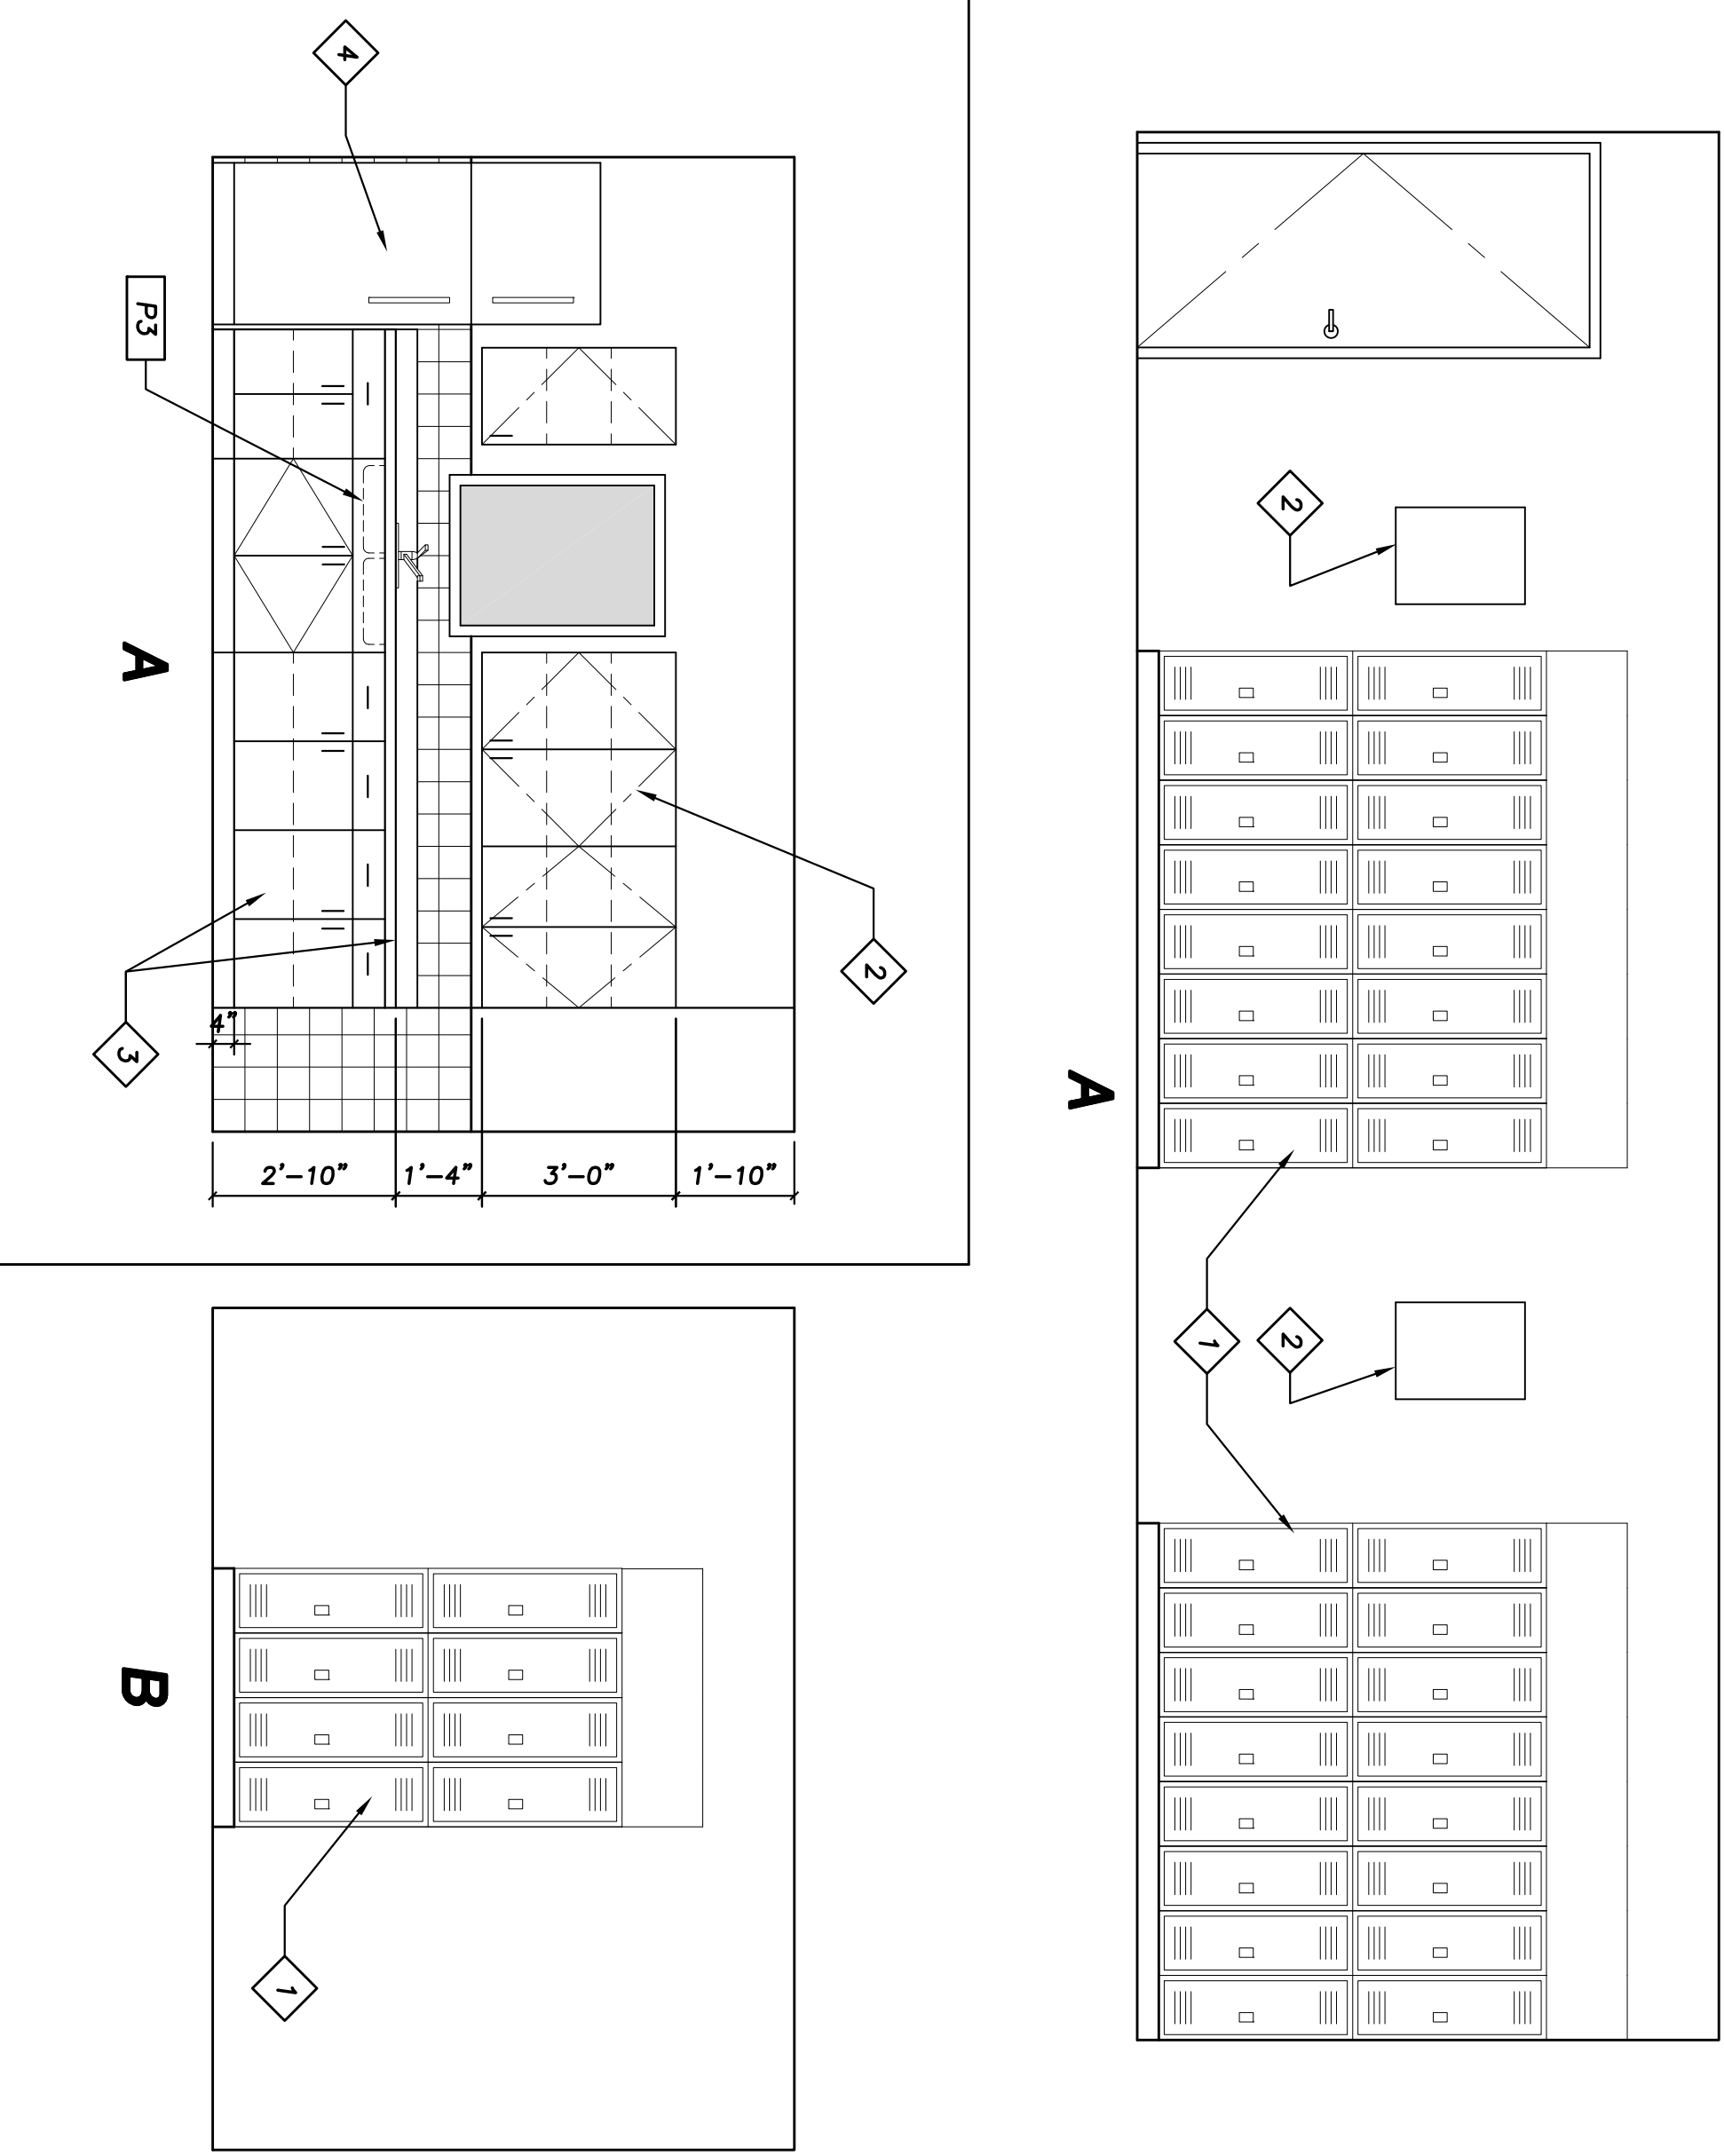

EXISTING BUILDING ENLARGED FLOOR PLAN SCALE: 1/4"=1'-0" 1

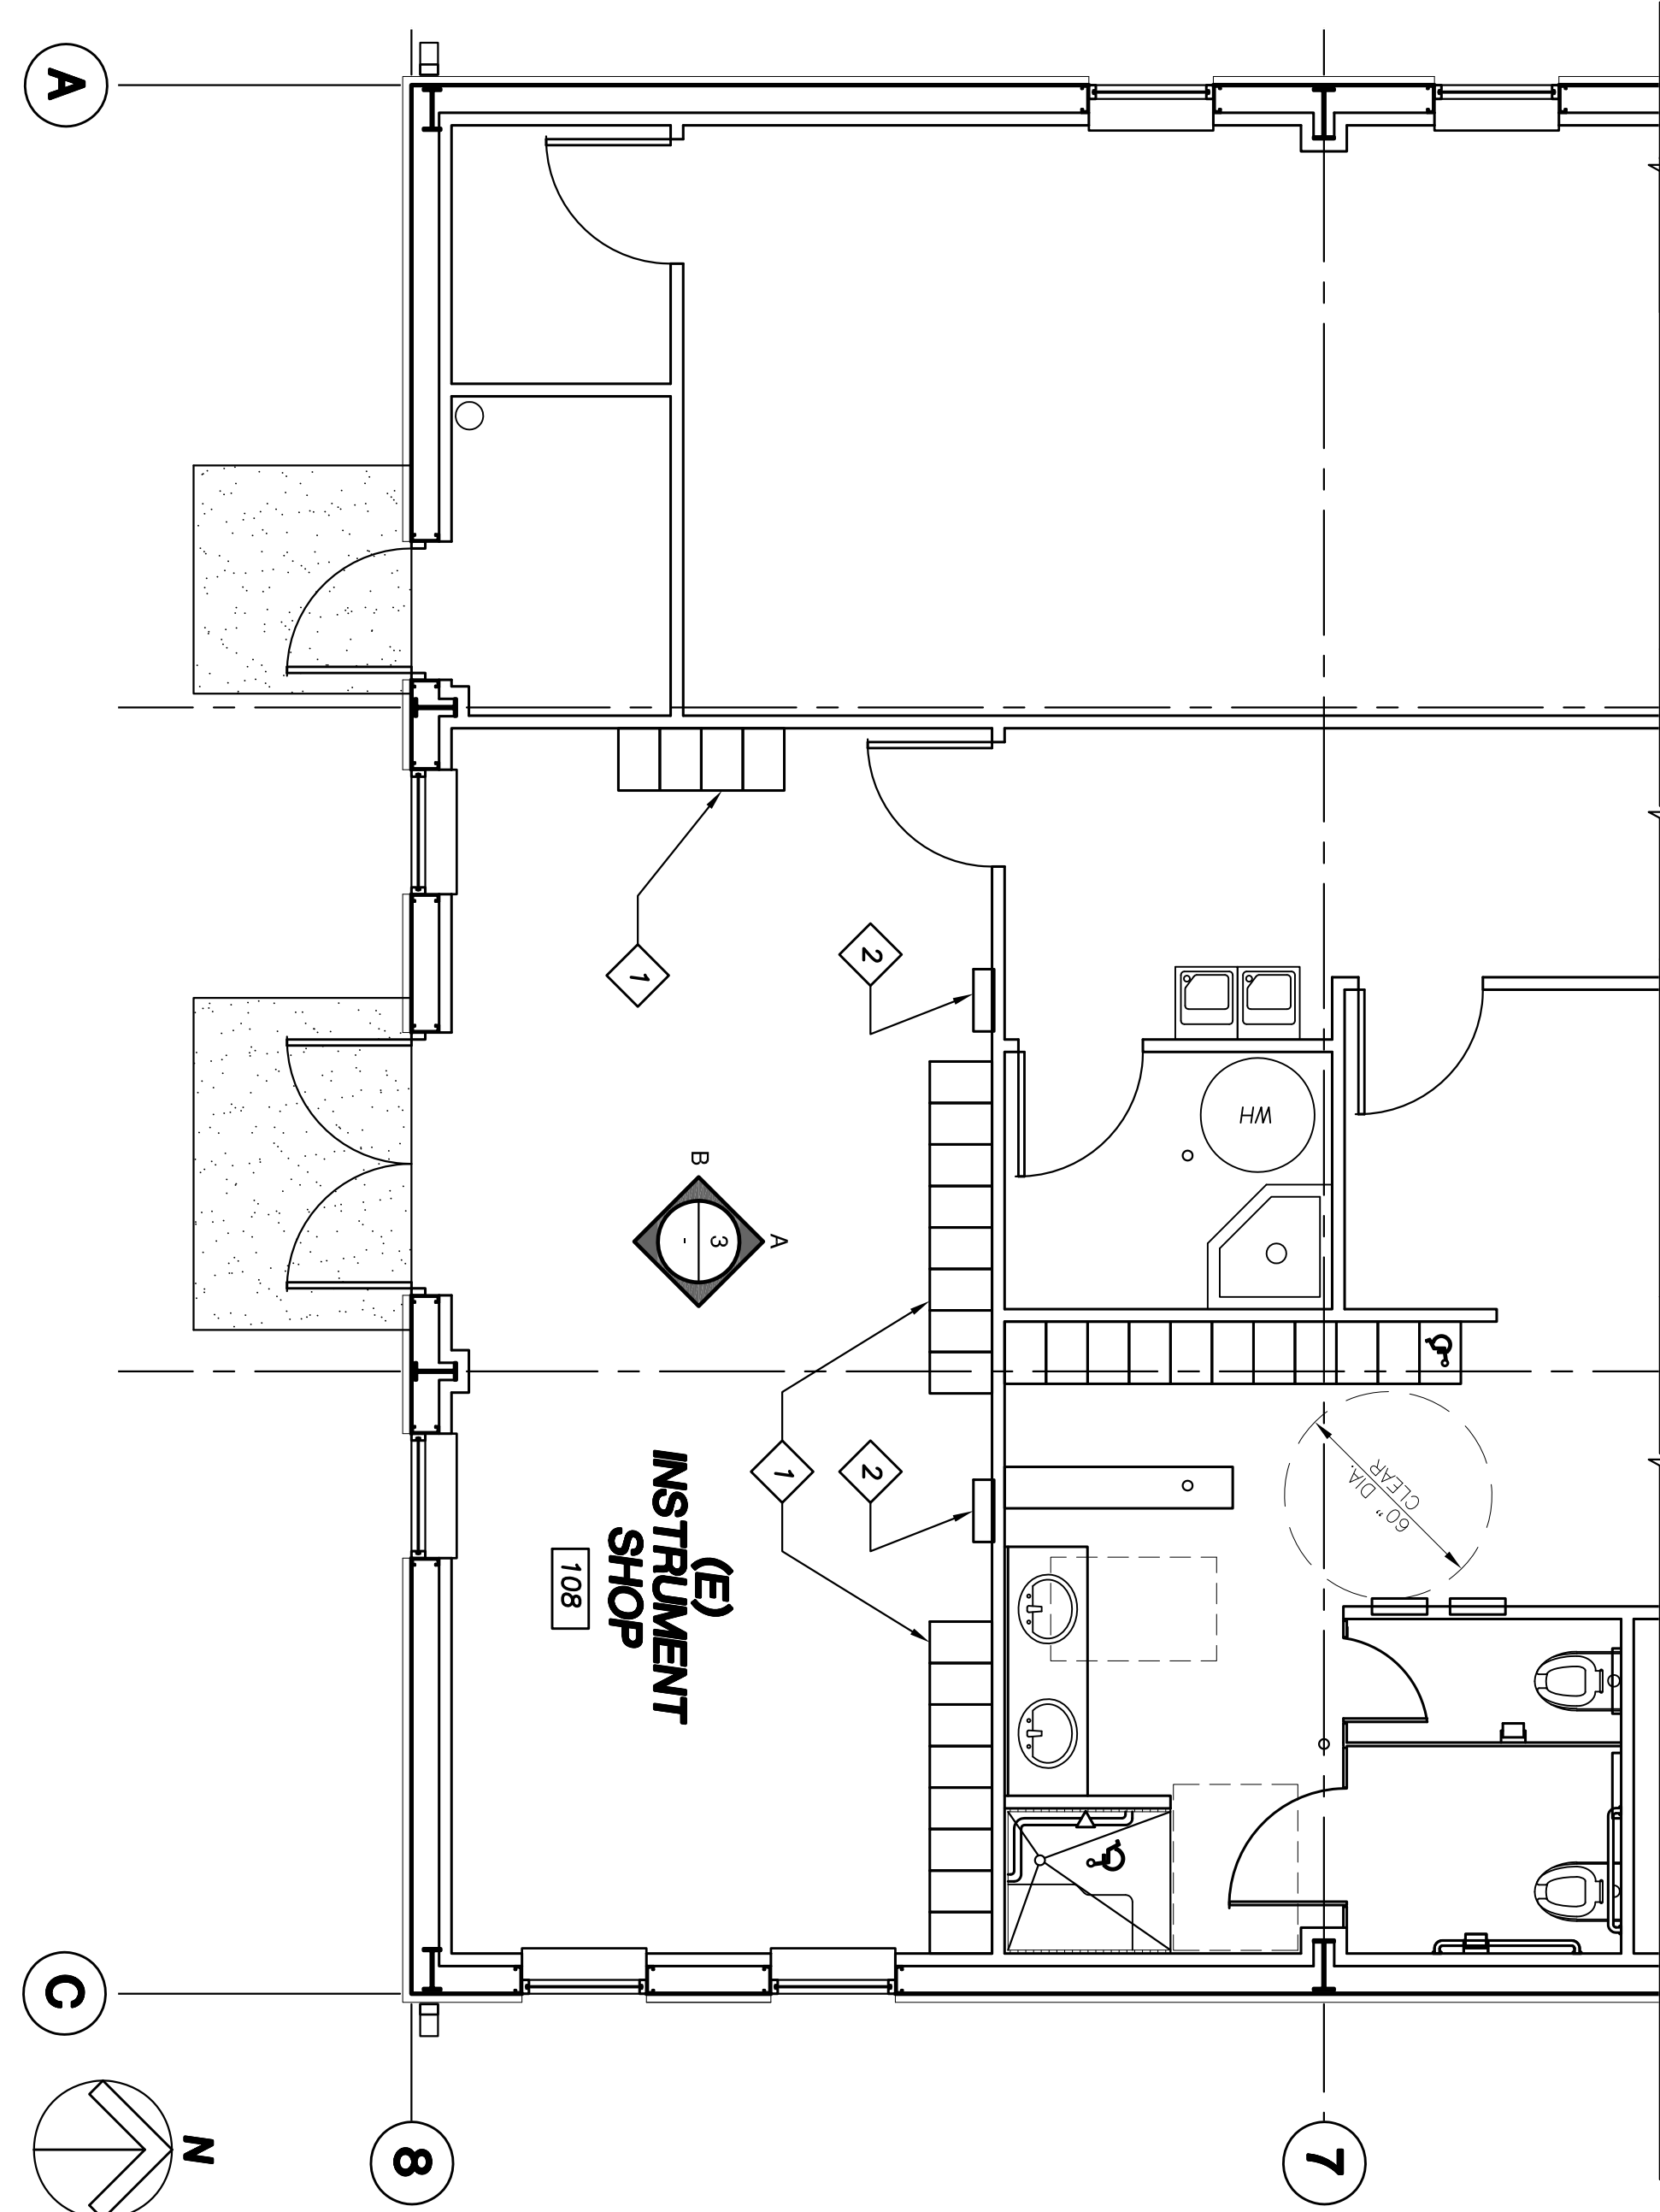


INT. ELEVATIONS-BREAK RM 204 SCALE: 3/8"=1'-0" 4 (E) INSTR. SHOP 108 SCALE: 3/8"=1'-0" 3

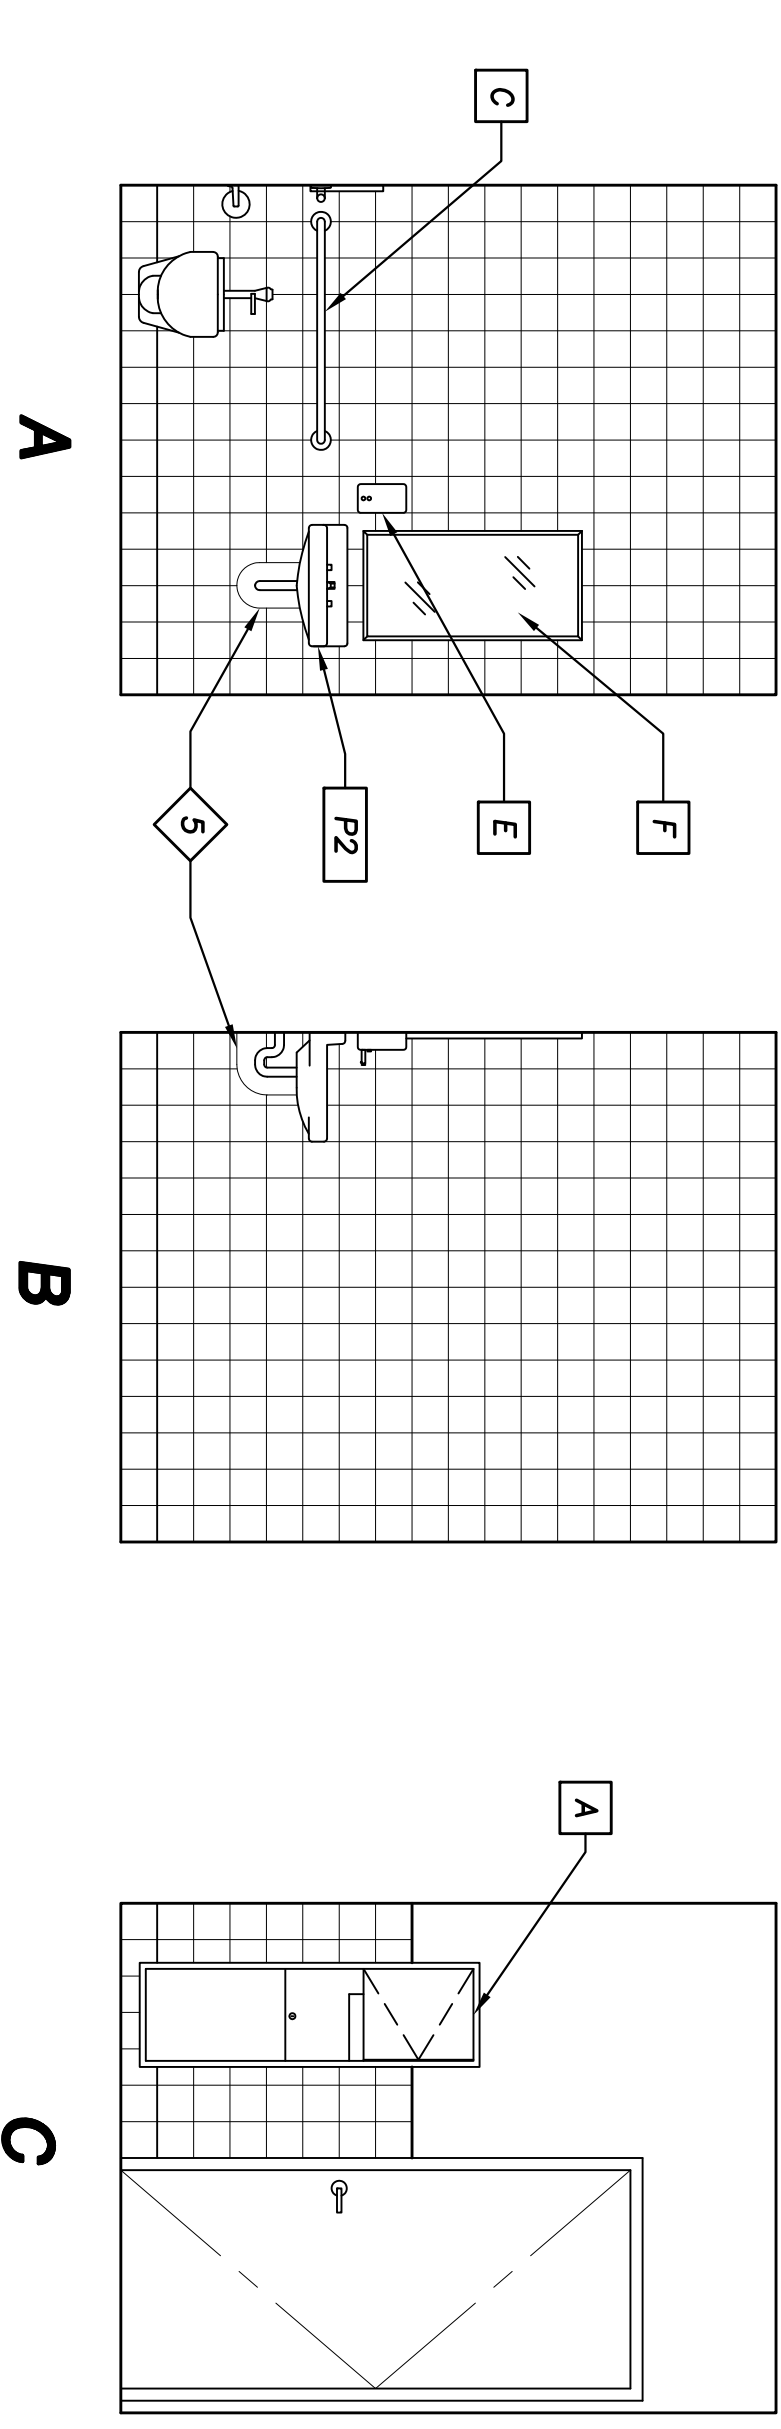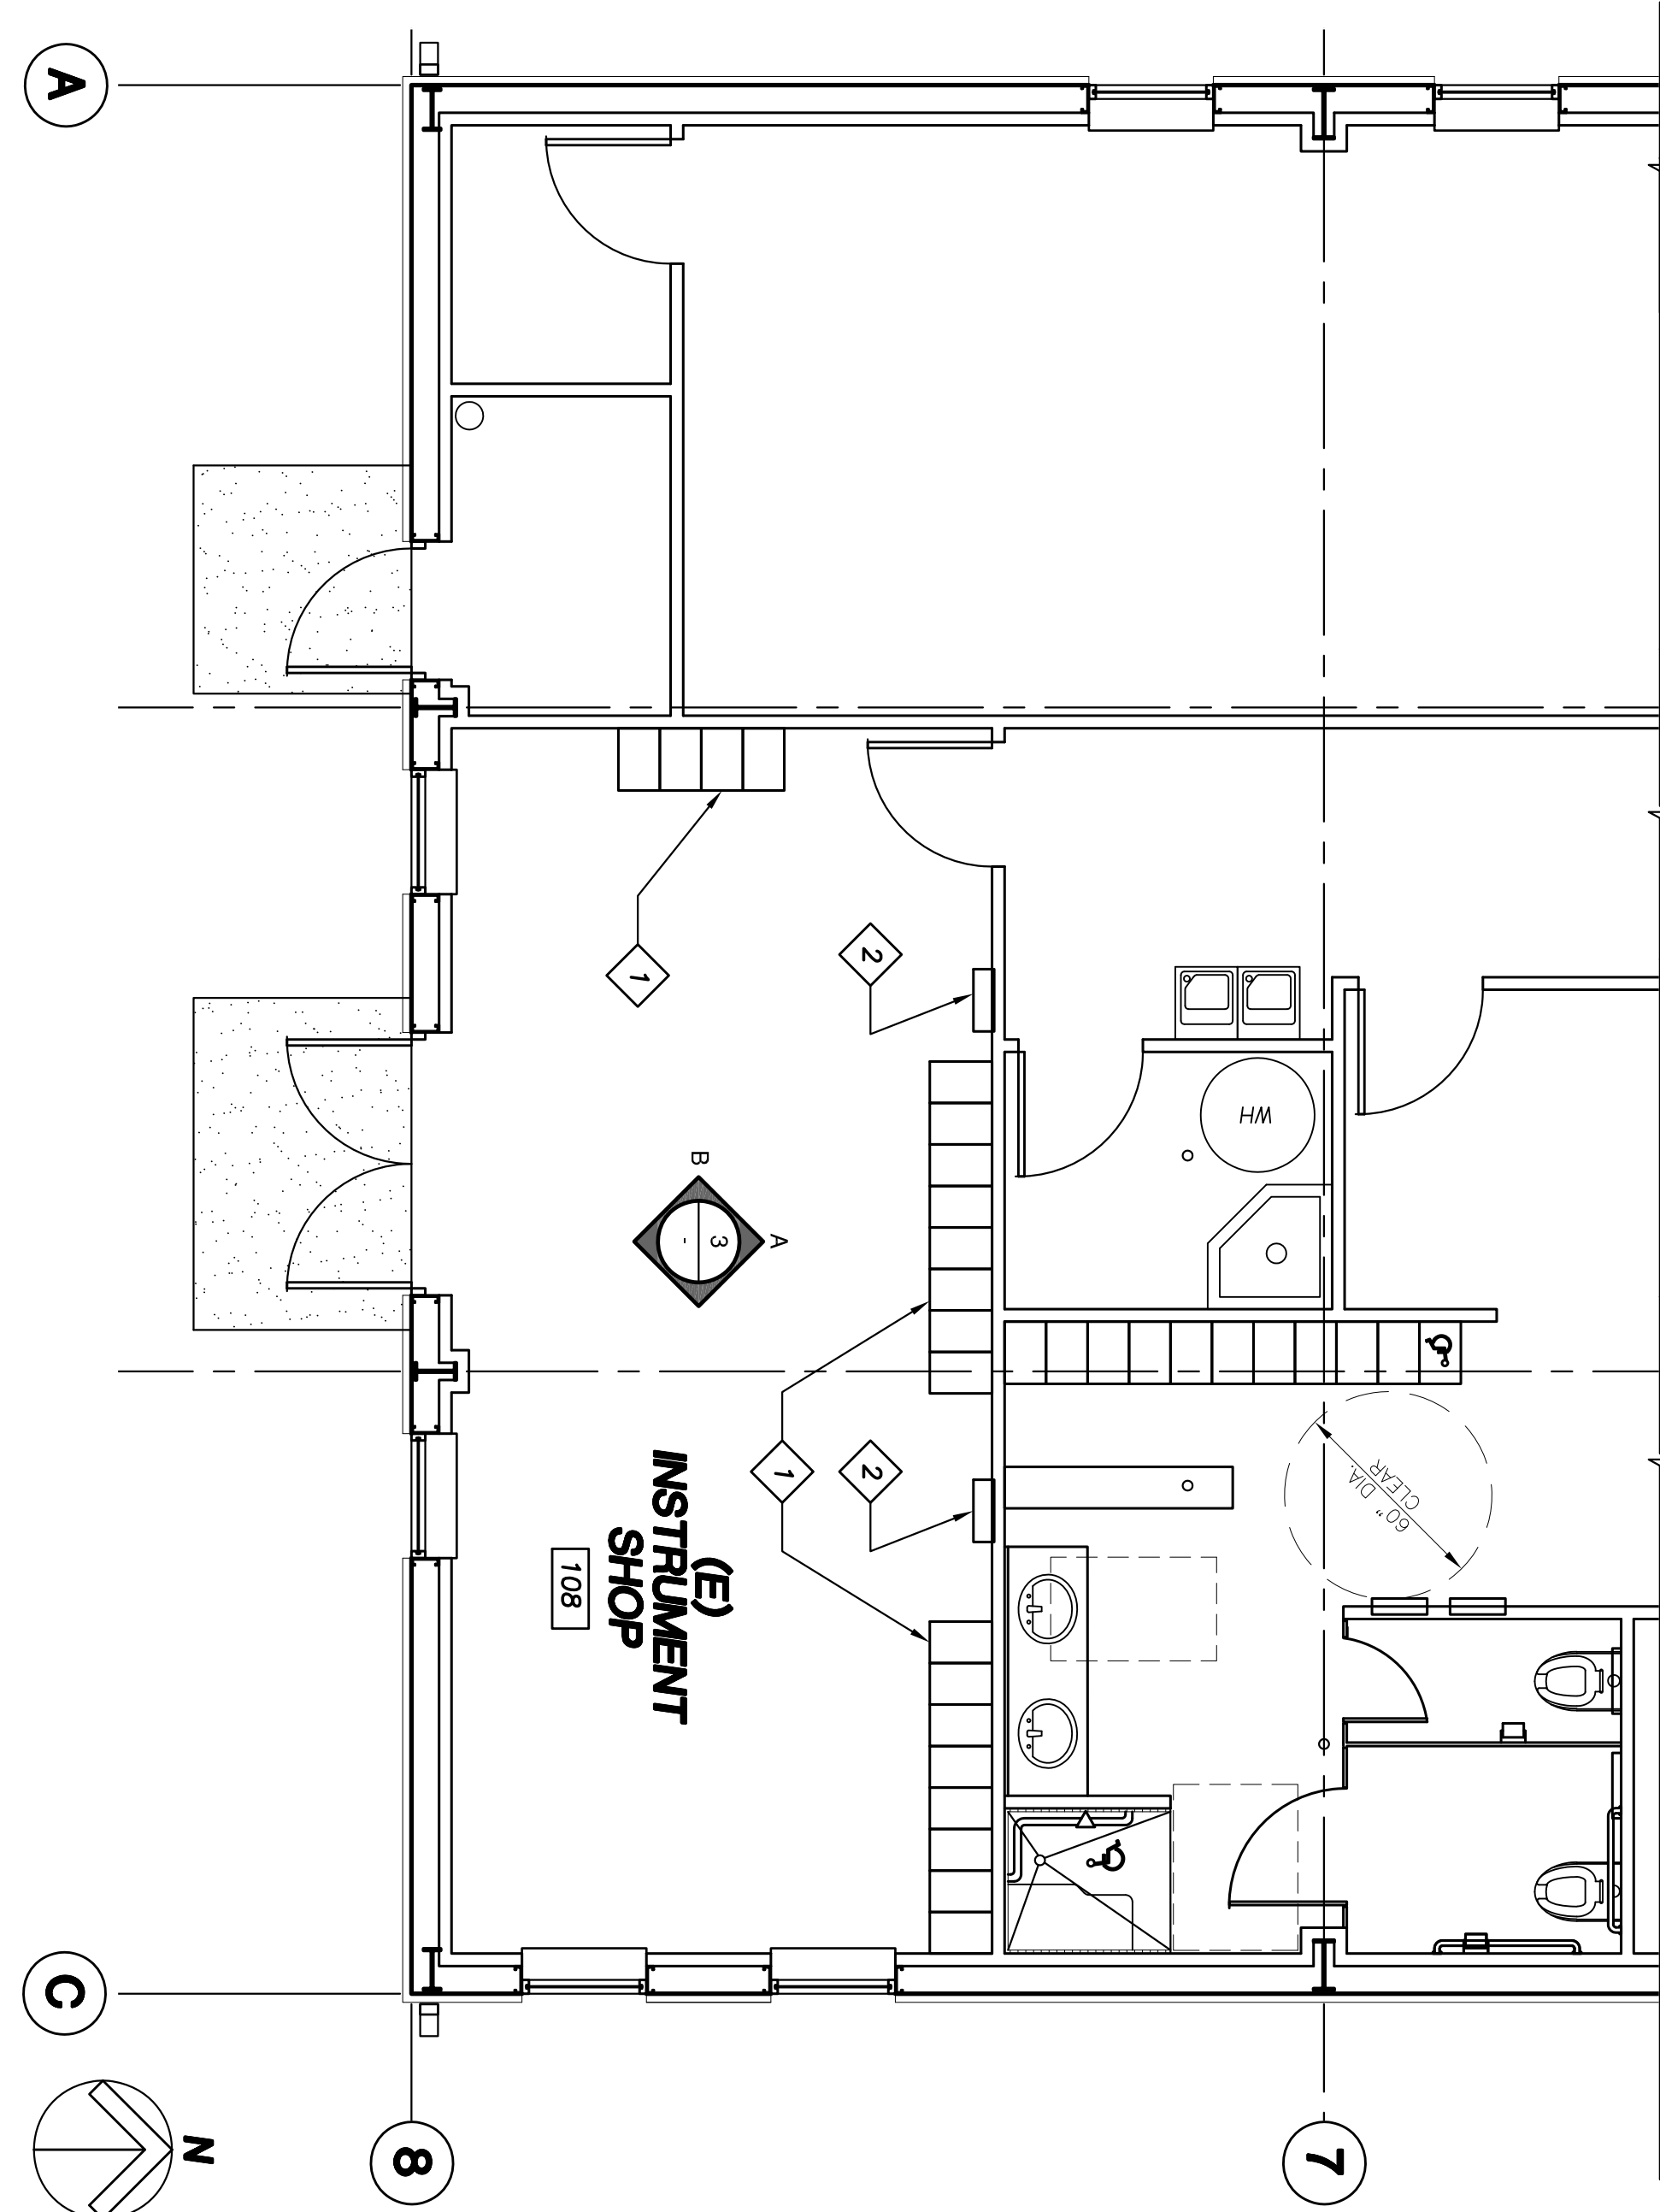

ACCESSORY SCHEDULE			
ITEM	MANUF.	CAT. NO.	FINISH
A COMBO TOWEL DISPENSER/WASTE RECEPTACLE	BOBRICK	B-3942	SATIN FINISH STAINLESS STEEL
B TOILET PAPER DISPENSER	BOBRICK	B-274	SATIN FINISH STAINLESS STEEL
C 36" GRAB BAR	BOBRICK	B-5806x36	SATIN FINISH STAINLESS STEEL
D 42" GRAB BAR	BOBRICK	B-5806x42	SATIN FINISH STAINLESS STEEL
E SOAP DISPENSER	BOBRICK	B-2111	SATIN FINISH STAINLESS STEEL
F MIRROR	BOBRICK	B-165-1836	SATIN FINISH STAINLESS STEEL
G SEAT COVER DISPENSER	BOBRICK	B-221	SATIN FINISH STAINLESS STEEL


- NOTES:
- ACCESSORIES AND LOCATIONS TO CONFORM WITH ACCESSIBILITY DETAILS ON AC SHEETS
  - ACCESSORIES SHALL BE BOBRICK OR EQUAL.
  - LIST OF ACCESSORIES IS FOR EXAMPLE PURPOSES ONLY. PROVIDE ITEM COMPATIBLE WITH PRODUCTS IN EXISTING FACILITY AS REQUIRED.

INTERIOR ELEVATIONS UNISEX RESTROOM 205 SCALE: 3/8"=1'-0" 5

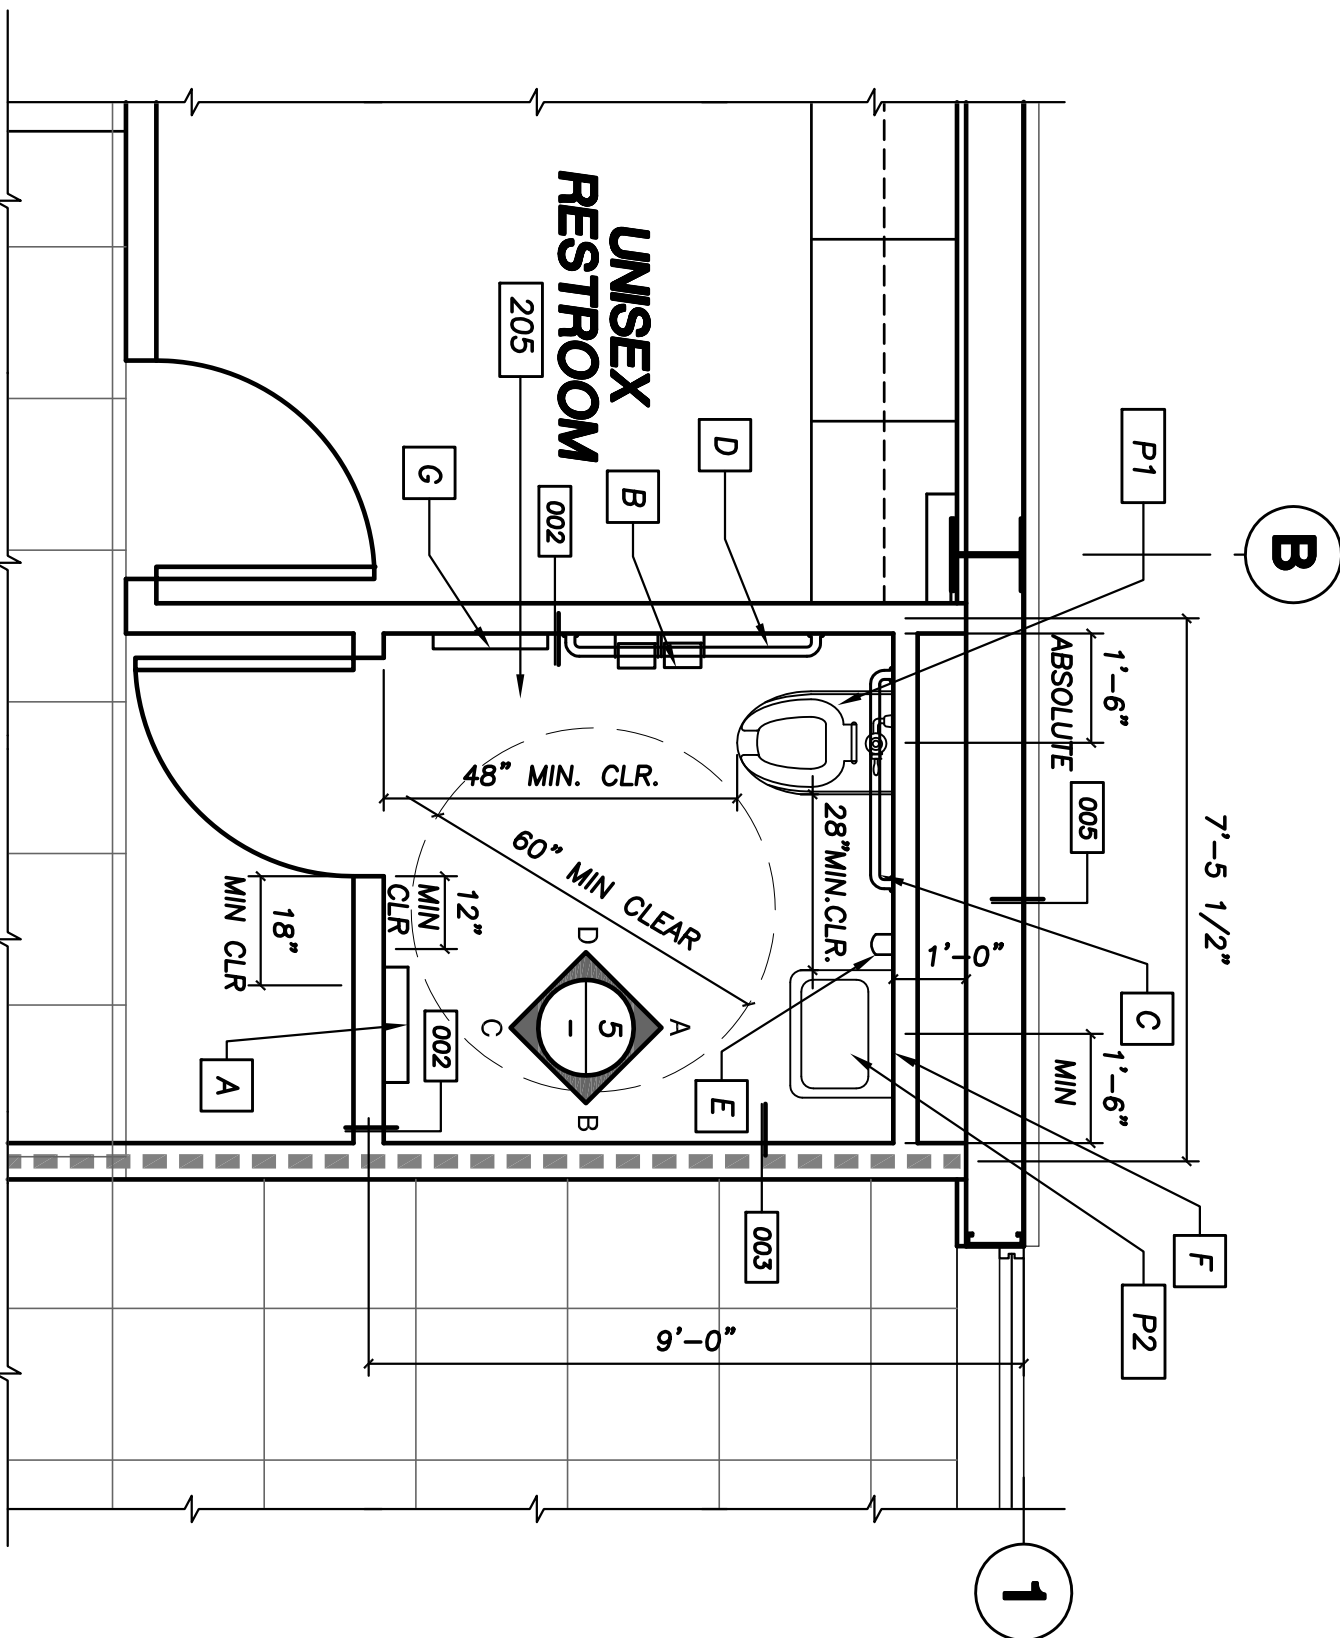

FOR ADDITIONAL DIMENSIONS AND MOUNTING  
HEIGHTS SEE AC SHEETS

ENLARGED FLOOR PLAN SCALE: 3/8"=1'-0" 2

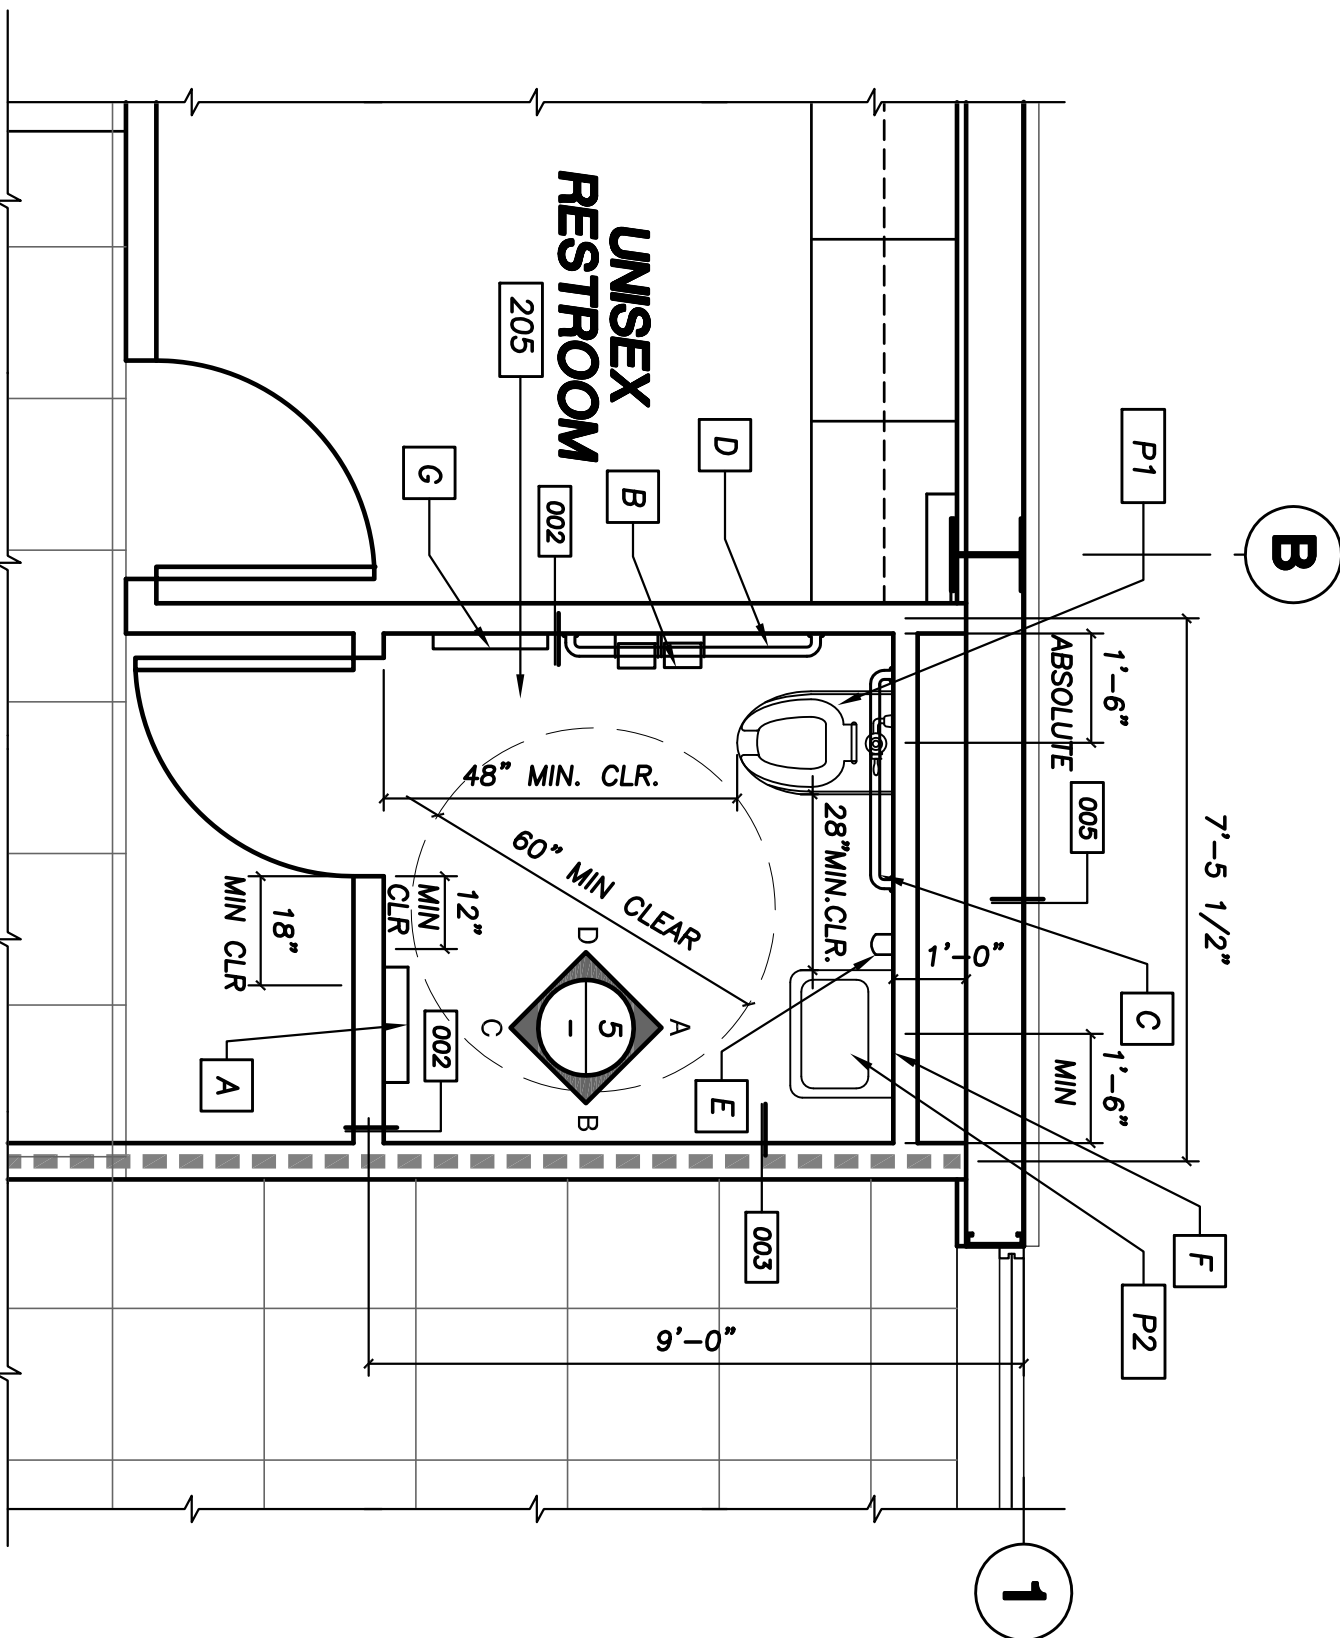

DESIGNED  
DRAWN  
CHECKED  
APPROVED

—  
BAP  
JAM  
—

DRAWING NUMBER  
**A2.2**

CONTROL BUILDING  
ENLARGED FLOOR PLAN & INTERIOR ELEVATIONS

STRUCTURAL ENGINEERS:  
**J. MILCZEWSKY  
and ASSOCIATES**

3275 E. DATE ST.  
BREDA, CA. 92823  
(714) 335-1289 BUS  
(714) 484-6012 FAX

JOB NUMBER 10-048

LOS ANGELES  
DEPARTMENT OF WATER AND POWER  
HAYNES GENERATING STATION  
UNITS 11-16

REGISTERED PROFESSIONAL ENGINEER  
No. 5169  
PE 5-34-13  
J. MILCZEWSKY  
DATE OF EXPIRATION  
12/31/16

DWP DRAWING NUMBER