

KEYNOTES

- 1 BUILDING LINE BELOW**
- 2 RIDGELINE**

P.E.M.B. KEYNOTES

- P1** METAL ROOF PANEL
- P2** METAL DOWNSPOUT
- P3** METAL EAVE FASCIA & GUTTER
- P4** METAL RAKE FASCIA

LEGEND

B.L. BUILDING LINE, INSIDE FACE OF PANEL AND
EDGE OF SLAB

A	100% SUBMITTAL	BP	JLM	11.30.11
REV	DESCRIPTION	DWN	CHK	APP
				DATE

LOS ANGELES
DEPARTMENT OF WATER AND POWER

HAYNES GENERATING STATION

UNITS 11-16

STRUCTURAL ENGINEERS:



**J. MILCZEWSKY
and ASSOCIATES**

**Kiewit Power
9401 Renner Boulevard
Lincoln, Kansas 66219**

3275 E. DATE ST.
BREA, CA. 92823
(714) 335-1289 BUS
(714) 494-8012 FAX

JOB NUMBER 10-048


CONTROL BUILDING ROOF PLAN

DWP DRAWING NUMBER

DRAWING NUMBER

DESIGNED	-
DRAWN	BAP
CHECKED	JAM
APPROVED	-

A4.1

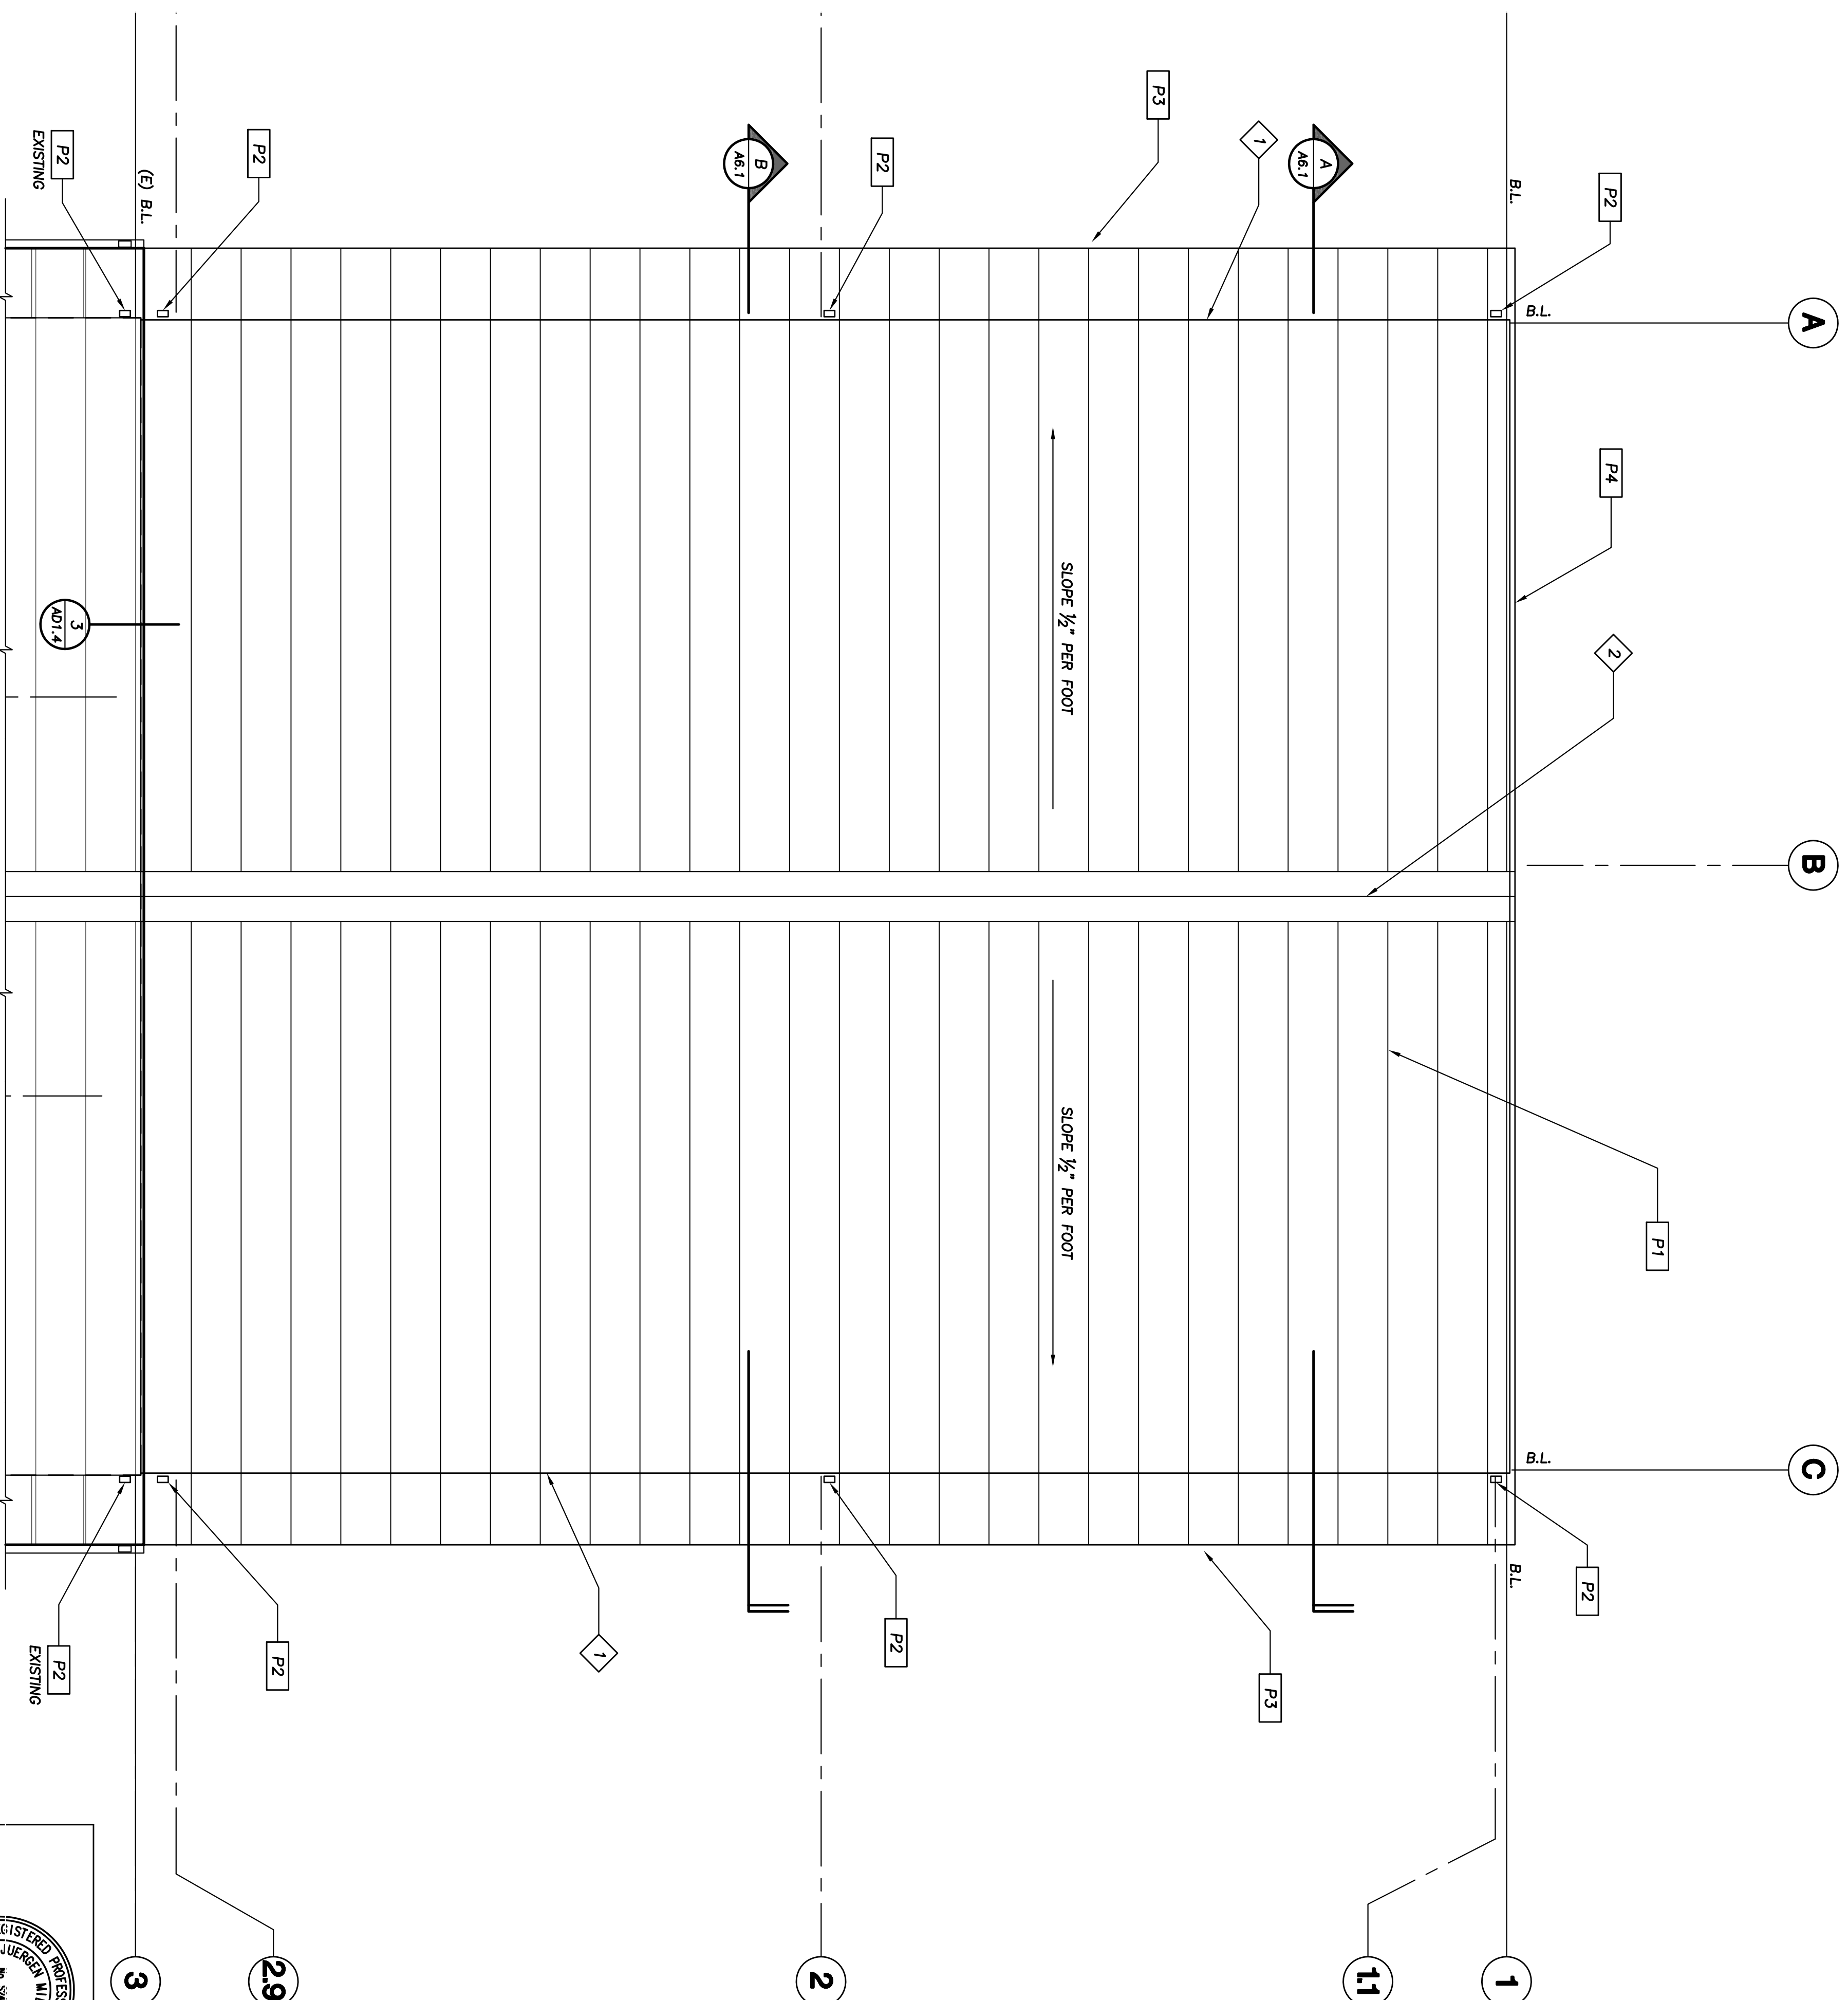

ROOF PLAN

SCALE:	1
$1/4"=1'-0"$	

1