

KEYNOTES

- 1 CONCRETE SPLASH BLOCK
- 2 CONCRETE LANDING PER PLAN
- 3 WALLPACK LIGHT PER ELECTRICAL

P.EMB. KEYNOTES

- P1 METAL ROOF PANEL
- P2 METAL DOWNSPOUT
- P3 METAL EAVE FASCIA & GUTTER
- P4 METAL RAKE FASCIA
- P5 EXTERIOR METAL WALL PANEL
- P6 DOOR PER SCHEDULE
- P7 WINDOW PER SCHEDULE

LEGEND

B.L. BUILDING LINE, INSIDE FACE OF PANEL AND
EDGE OF SLAB

A	100% SUBMITTAL	BP	JM	-	11.30.11
REV	DESCRIPTION	DWN	CHK	APP	DATE

LOS ANGELES
DEPARTMENT OF WATER AND POWER

HAYNES GENERATING STATION
UNITS 11-16



Kiewit

STRUCTURAL ENGINEERS:
**J. MILCZEWSKY
and ASSOCIATES**

3275 E. DATE ST.
BREDA, CA. 92823
(714) 335-4289 BUS
(714) 454-6012 FAX


Professional Engineer
No. 5069
Exp. 3-31-13
JACOB MILCZEWSKY
STATE OF CALIFORNIA
DIVISION OF PROFESSIONAL ENGINEERS

Scott Porter
Project Engineer
License No. 662316

JOB NUMBER 10-048

CONTROL BUILDING
EXTERIOR ELEVATIONS


DESIGNED	-	DRAWING NUMBER	A5.1
DRAWN	BAP		
CHECKED	JAM		
APPROVED	-		

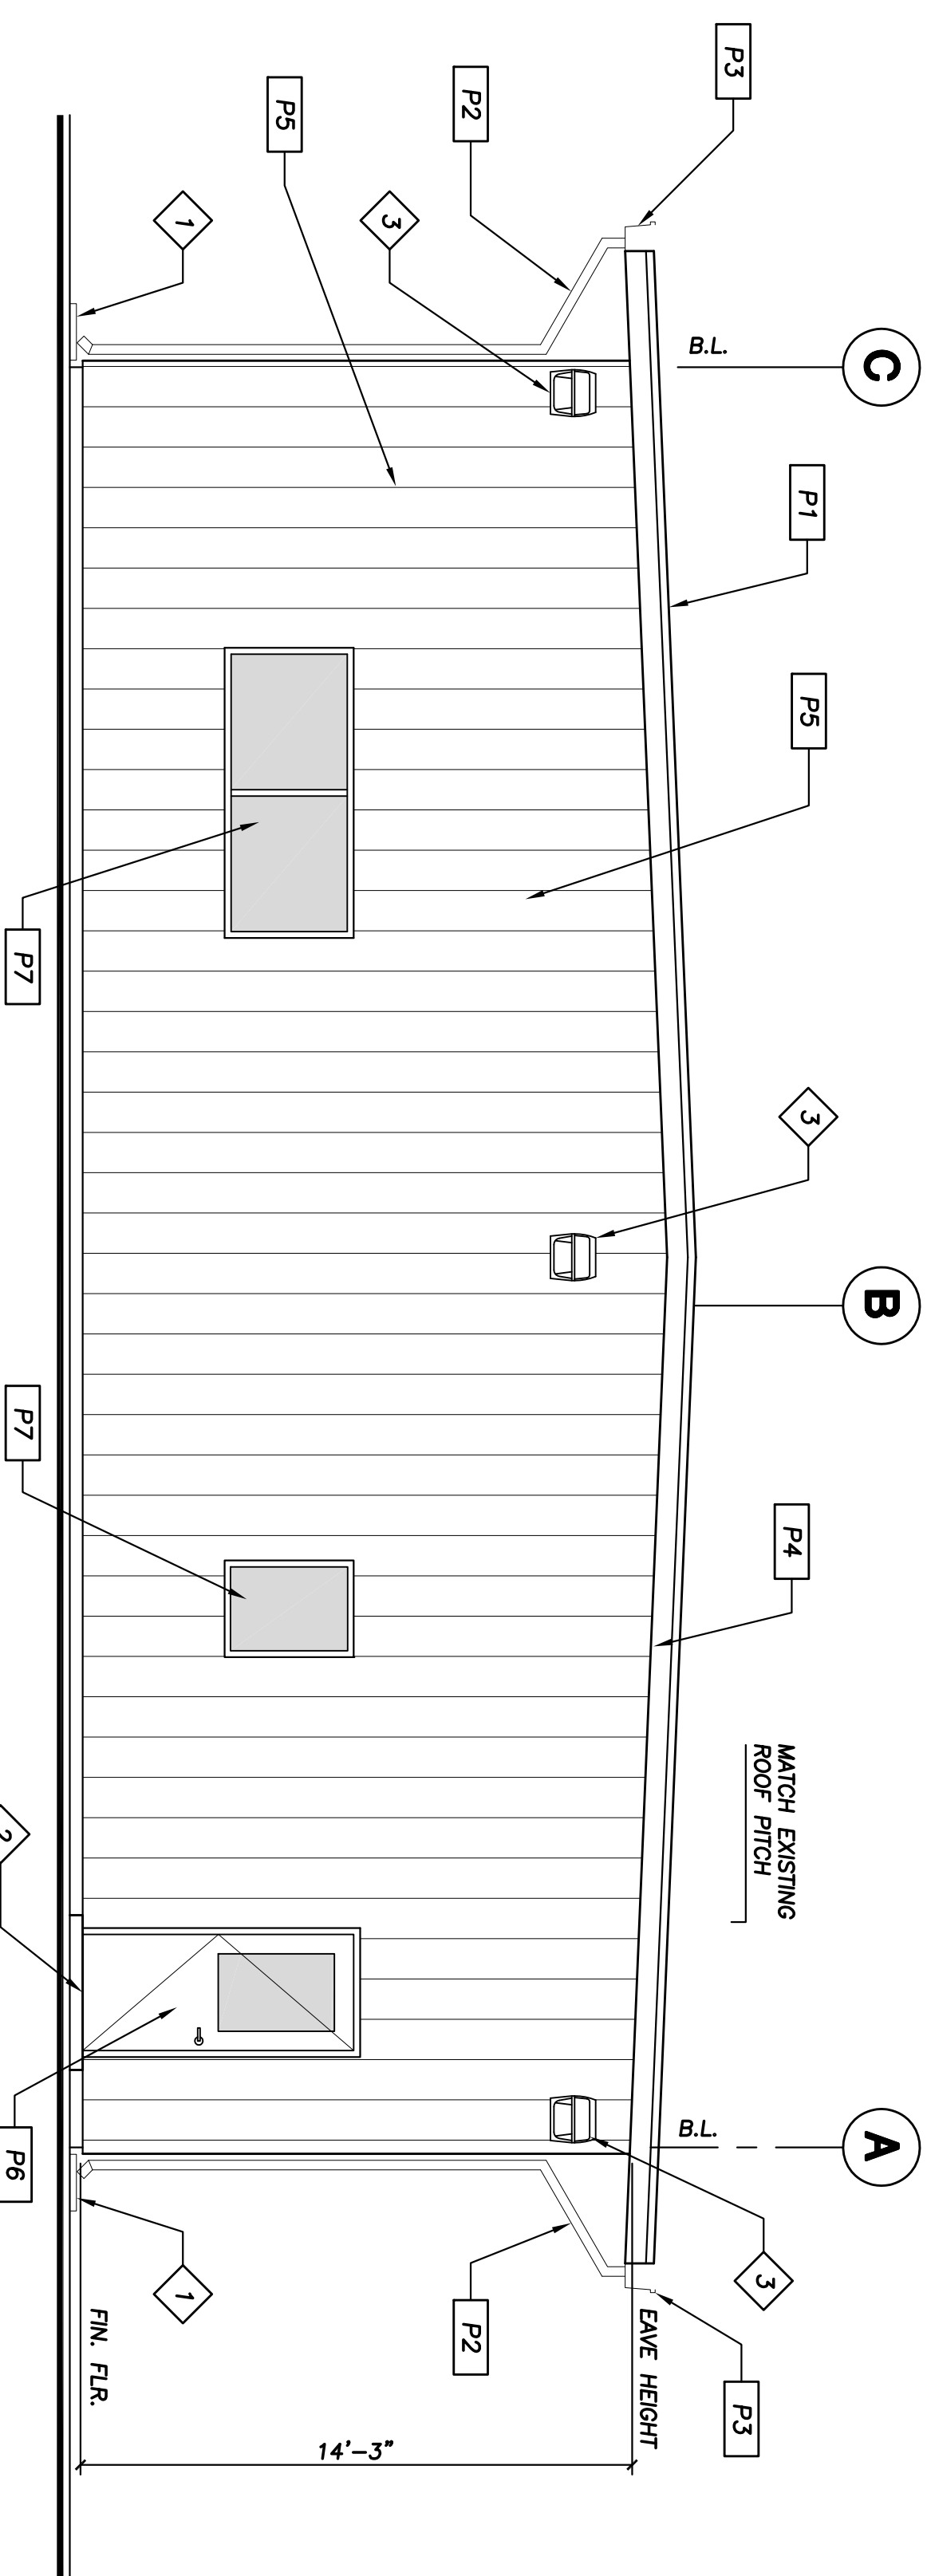

NORTH ELEVATION

SCALE: 1/4"=1'-0"


1

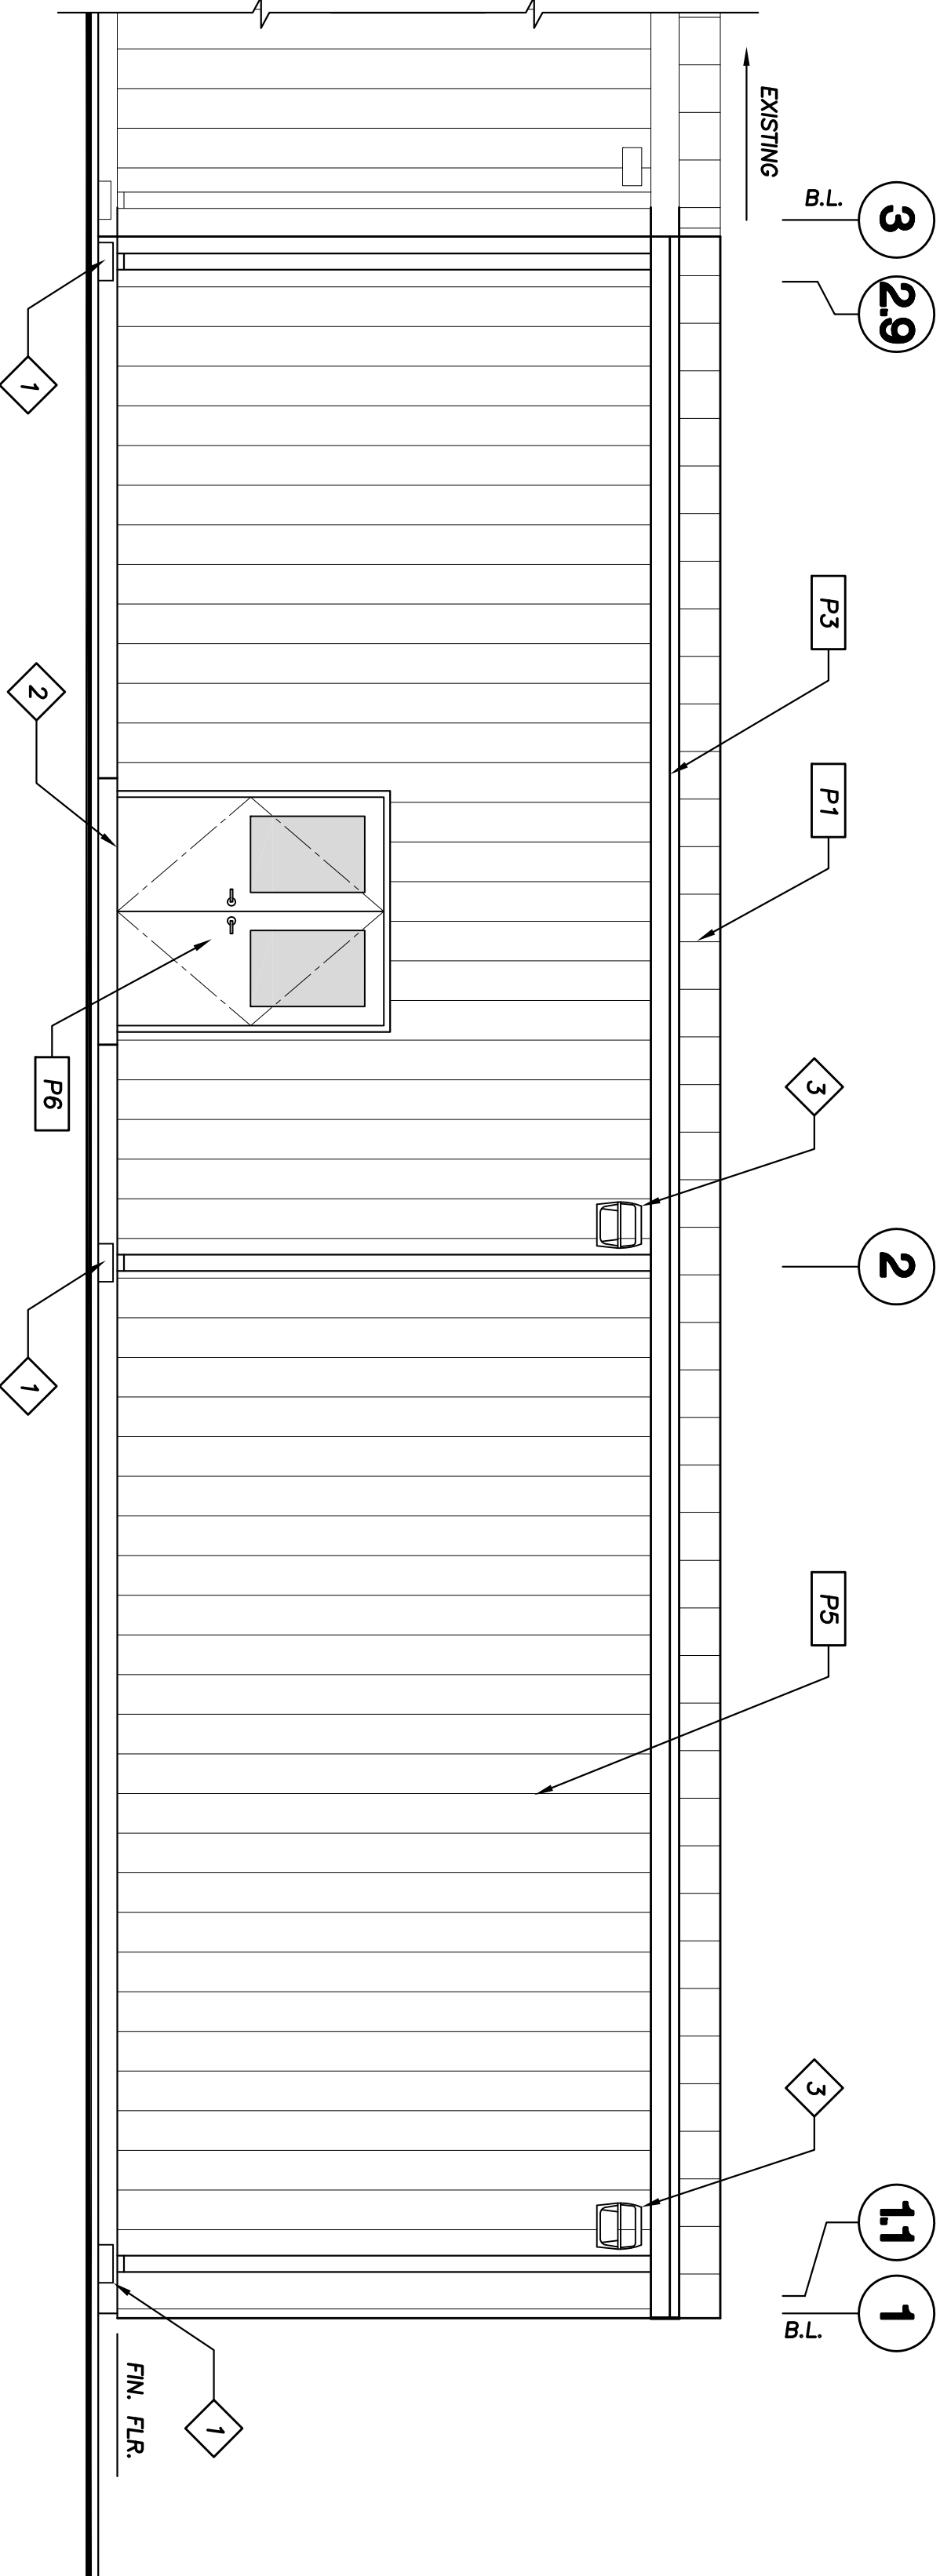

EAST ELEVATION

SCALE: 1/4"=1'-0"

2

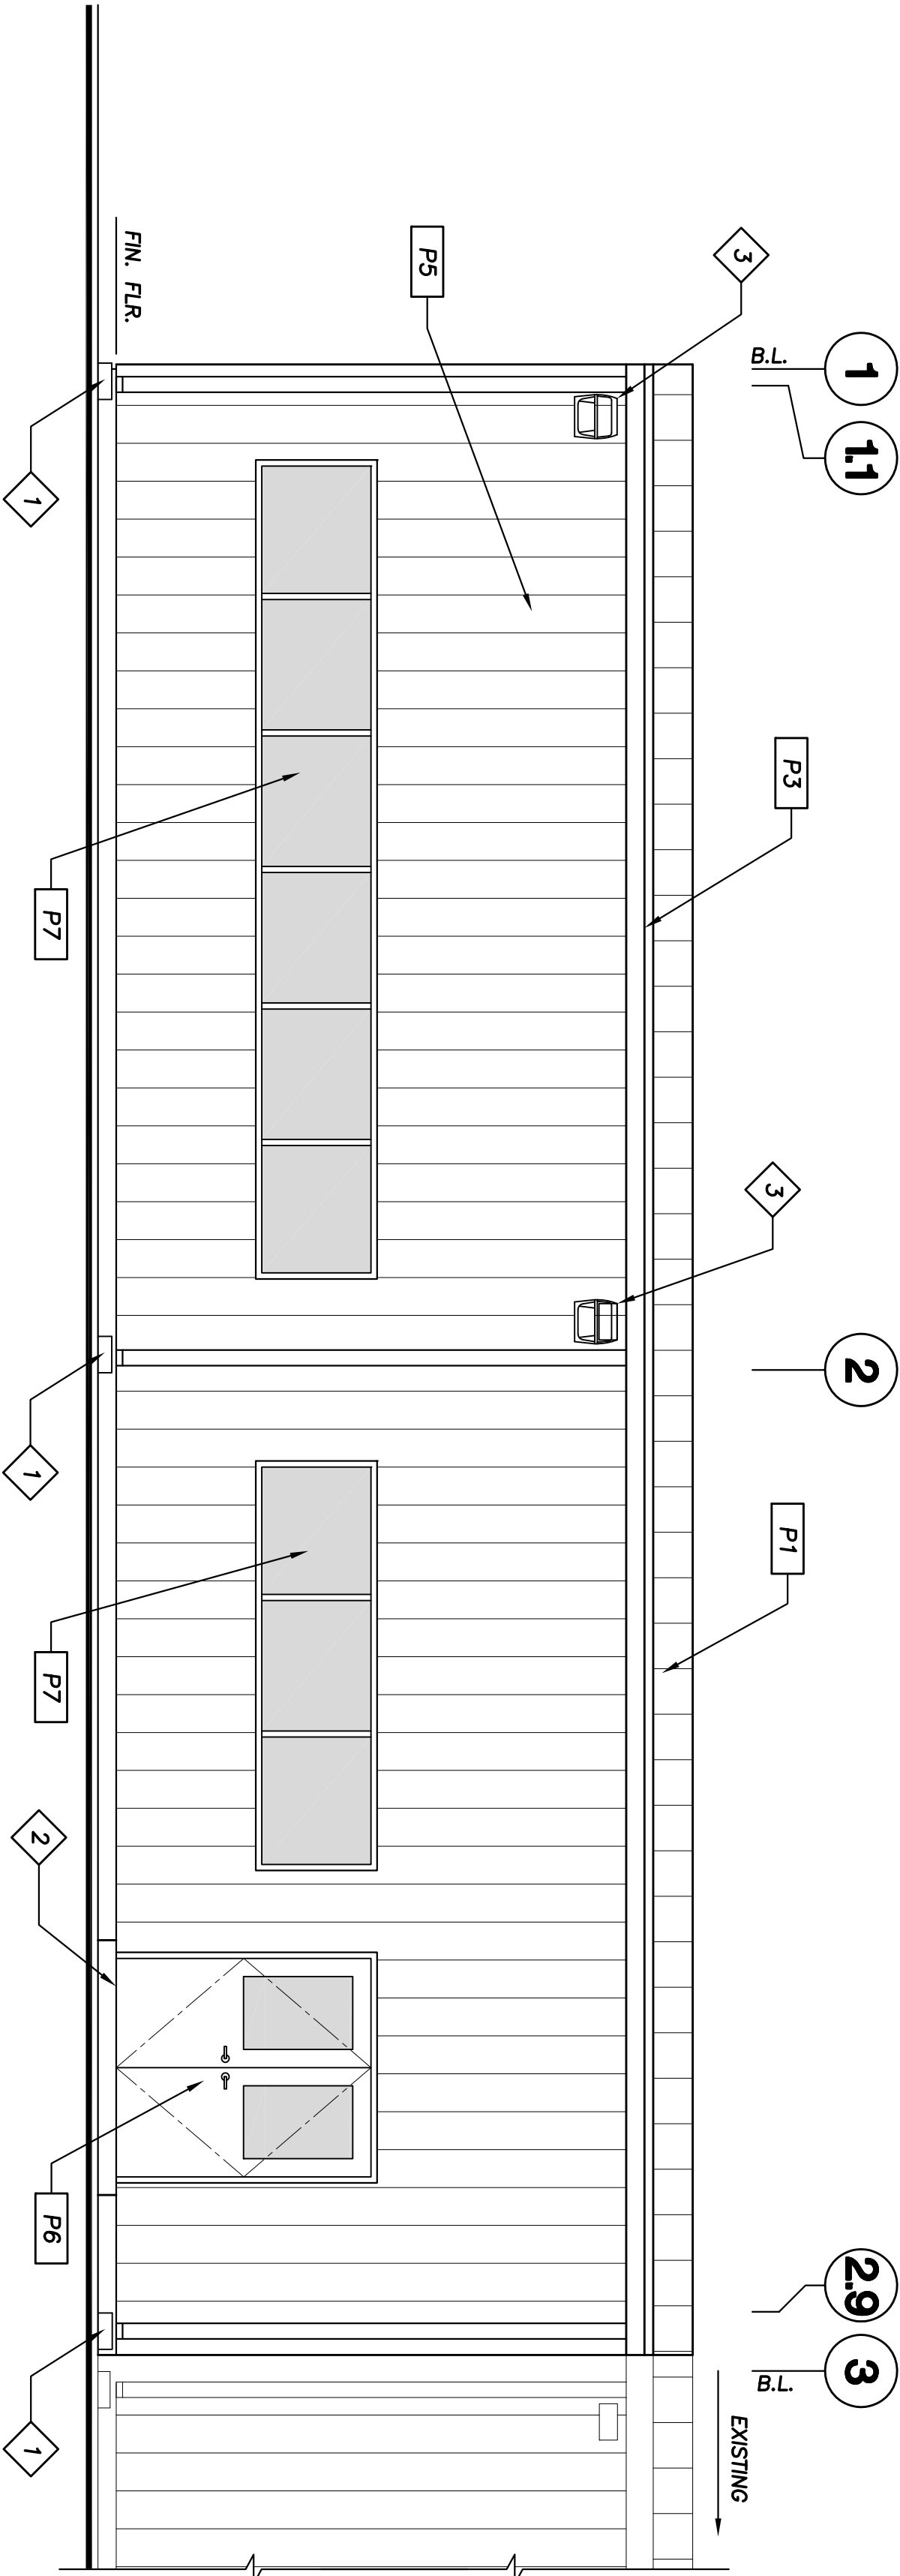

WEST ELEVATION

SCALE: 1/4"=1'-0"

3