


KEYNOTES

- 1 CONCRETE FOOTING PER STRUCTURAL
- 2 RECESSED FLOOR SLAB PER STRUCTURAL
- 3 COMPUTER FLOORING PER FINISH SCHEDULE SEE DETAIL 5/A01.2
- 4 FLOOR SLAB PER STRUCTURAL
- 5 R-11 INSULATION TYPICAL IN EXTERIOR WALLS PER ENERGY CALCS
- 6 R-30 INSULATION TYPICAL AT ROOF PER ENERGY CALCS
- 7 SUSPENDED T-BAR CEILING PER REFLECTED CEILING PLAN & FINISH SCHEDULE. SEE DETAIL 8/A01.2
- 8 FURRED COLUMN. SEE DETAIL
- 9 WALL PER FLOOR PLAN & WALL TYPE DETAILS
- 10 METAL CEILING JOISTS PER REFLECTED CEILING PLAN
- 11 DIAGONAL METAL STRUTS
- 12 2 HOUR PARTITION WALL TO UNDERSIDE OF ROOF STRUCTURE SEE WALL TYPES

PEMB KEYNOTES


- P1 STRUCTURAL STEEL FRAME
- P2 ROOF PURLIN
- P3 METAL ROOF PANEL
- P4 METAL EAVE FASCIA & GUTTER
- P5 METAL SOFTT PANEL
- P6 EAVE STRUT
- P7 WALL GIRT
- P8 EXTERIOR METAL WALL PANEL

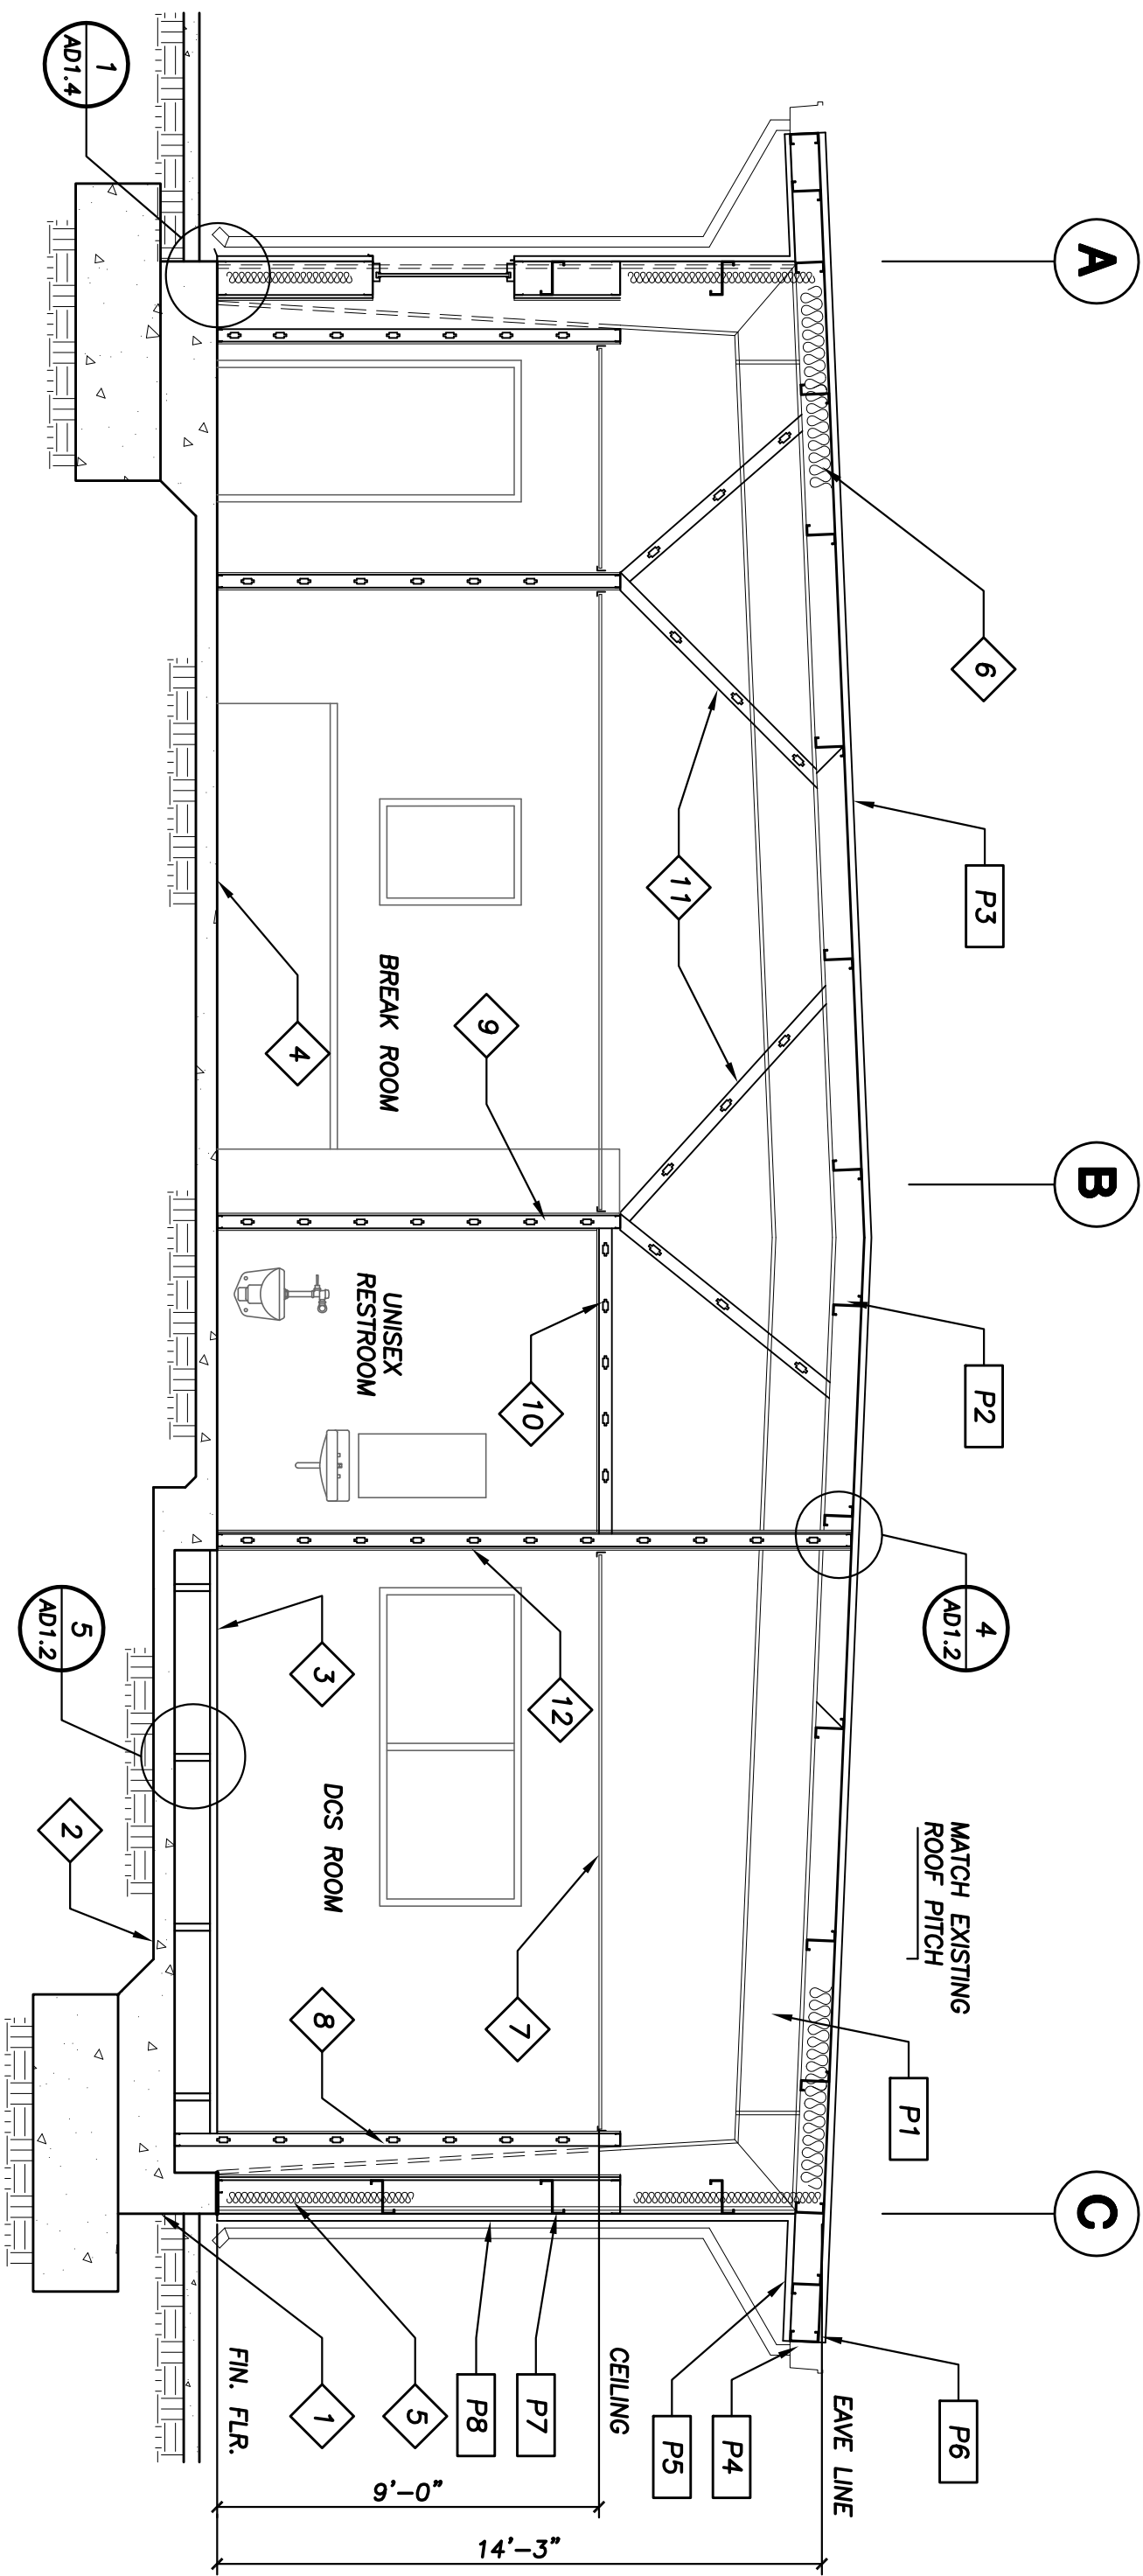

SECTION

SCALE: 1/4"=1'-0"

A

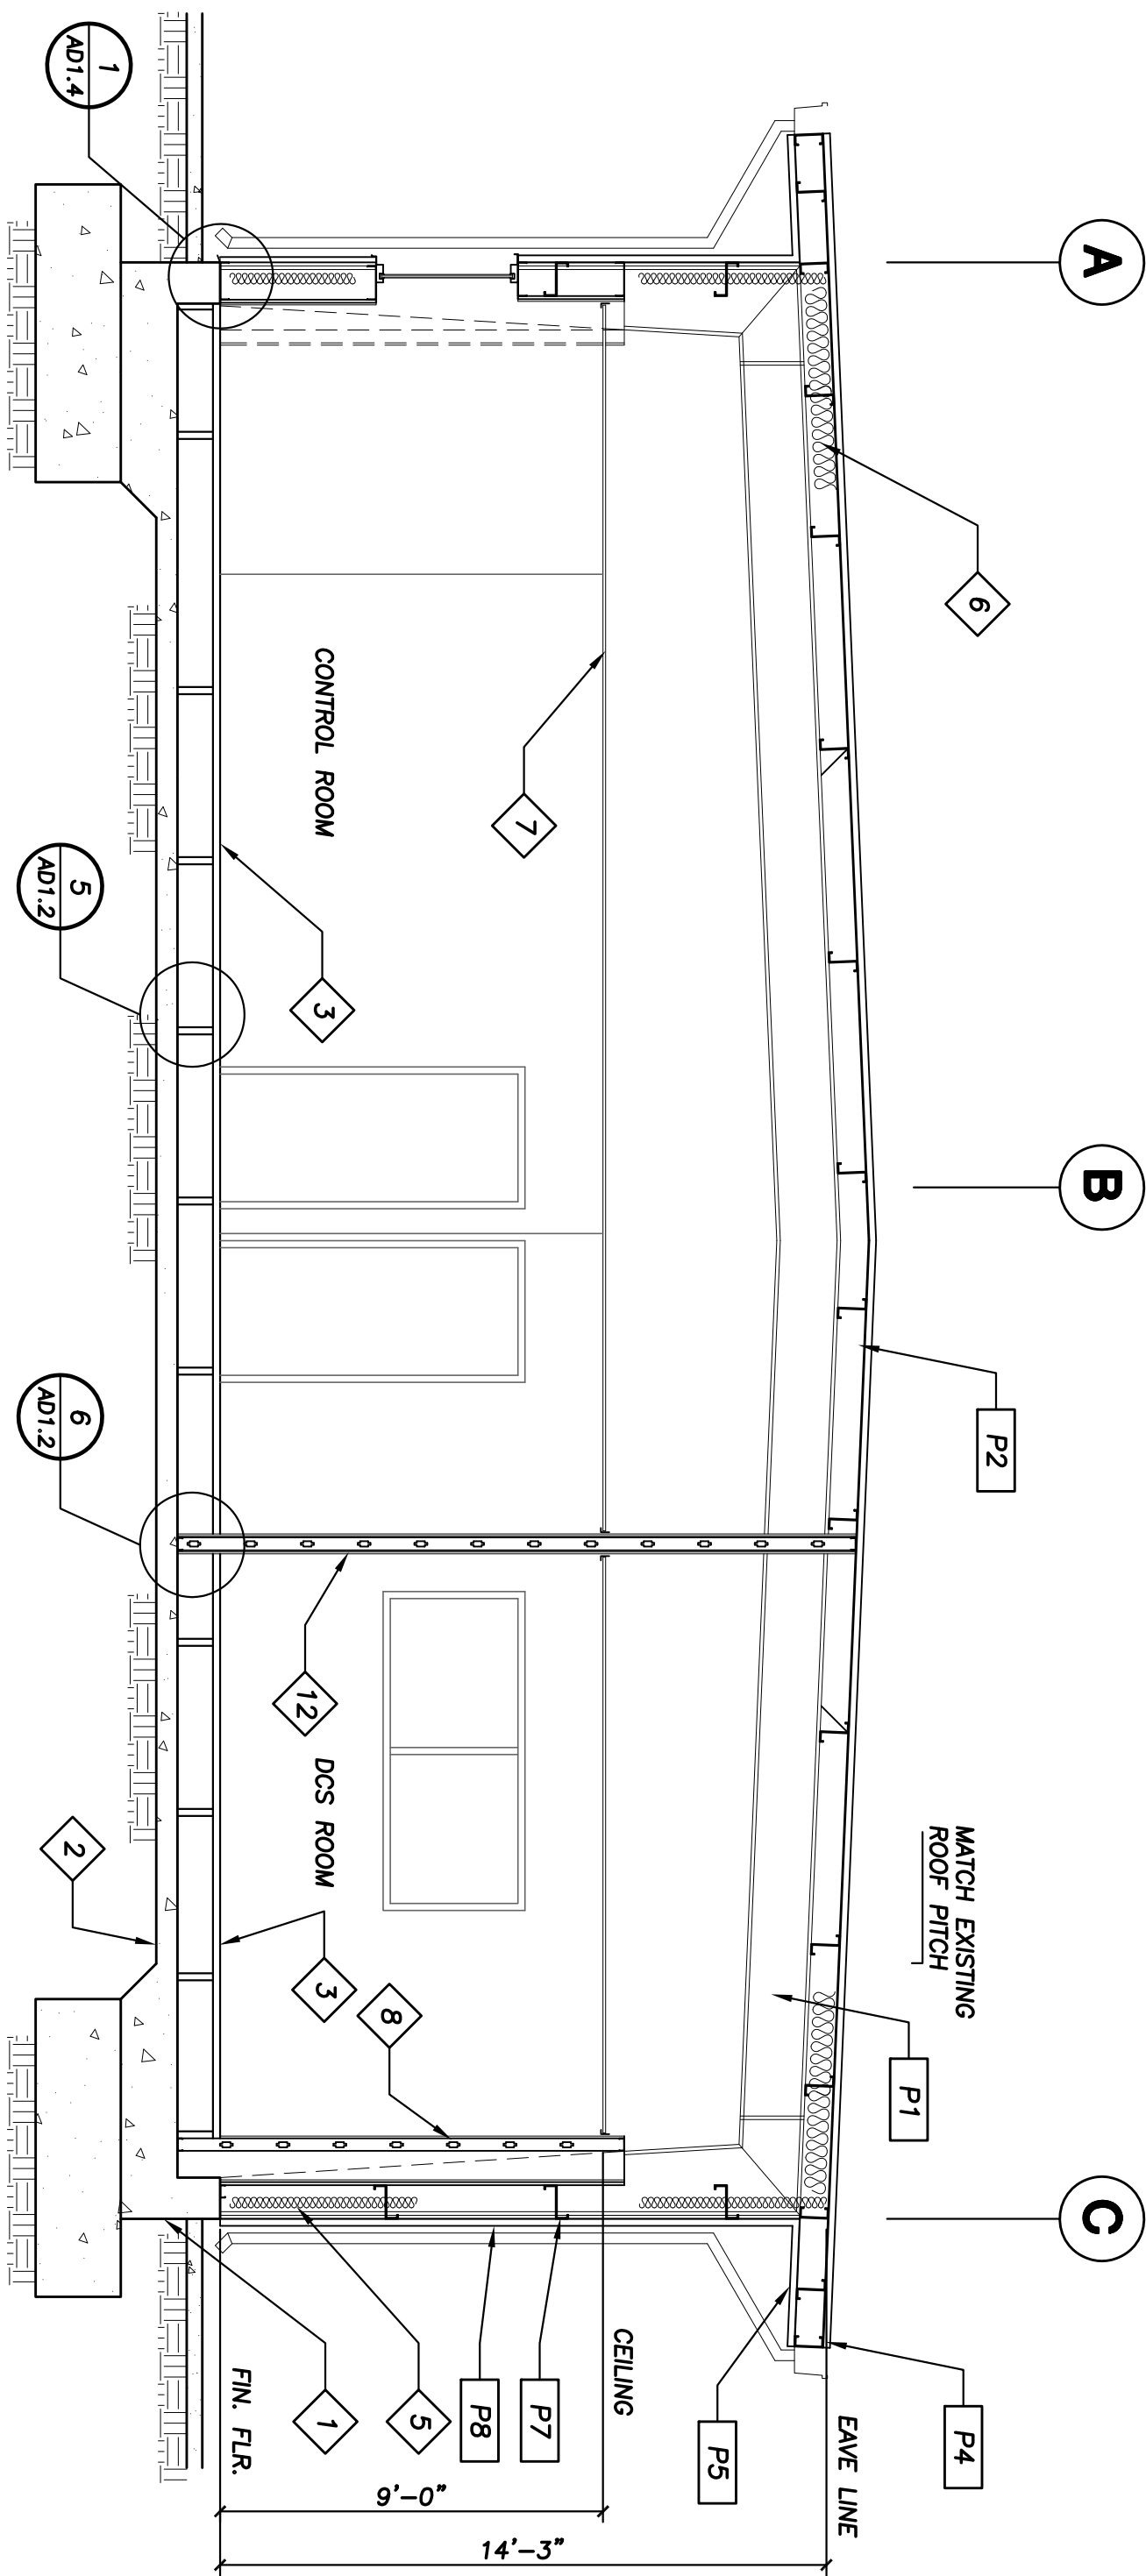

SECTION

SCALE: 1/4"=1'-0"

B

LOS ANGELES  
DEPARTMENT OF WATER AND POWER

HAYNES GENERATING STATION  
UNITS 11-16



STRUCTURAL ENGINEERS:  
**J. MILCZEWSKY**  
and ASSOCIATES

**Scott Foster**  
Professional Engineer  
No. 5069  
PE 5-34-13  
Haynes, Kernos 06216

3275 E. DATE ST.  
BREDA, CA. 92823  
(714) 335-1289 BUS  
(714) 454-6012 FAX

JOB NUMBER 10-048

CONTROL BUILDING  
SECTIONS

DWP DRAWING NUMBER

DESIGNED  
DRAIN BAP  
CHECKED JAM  
APPROVED -

DRAWING NUMBER

A6.1