


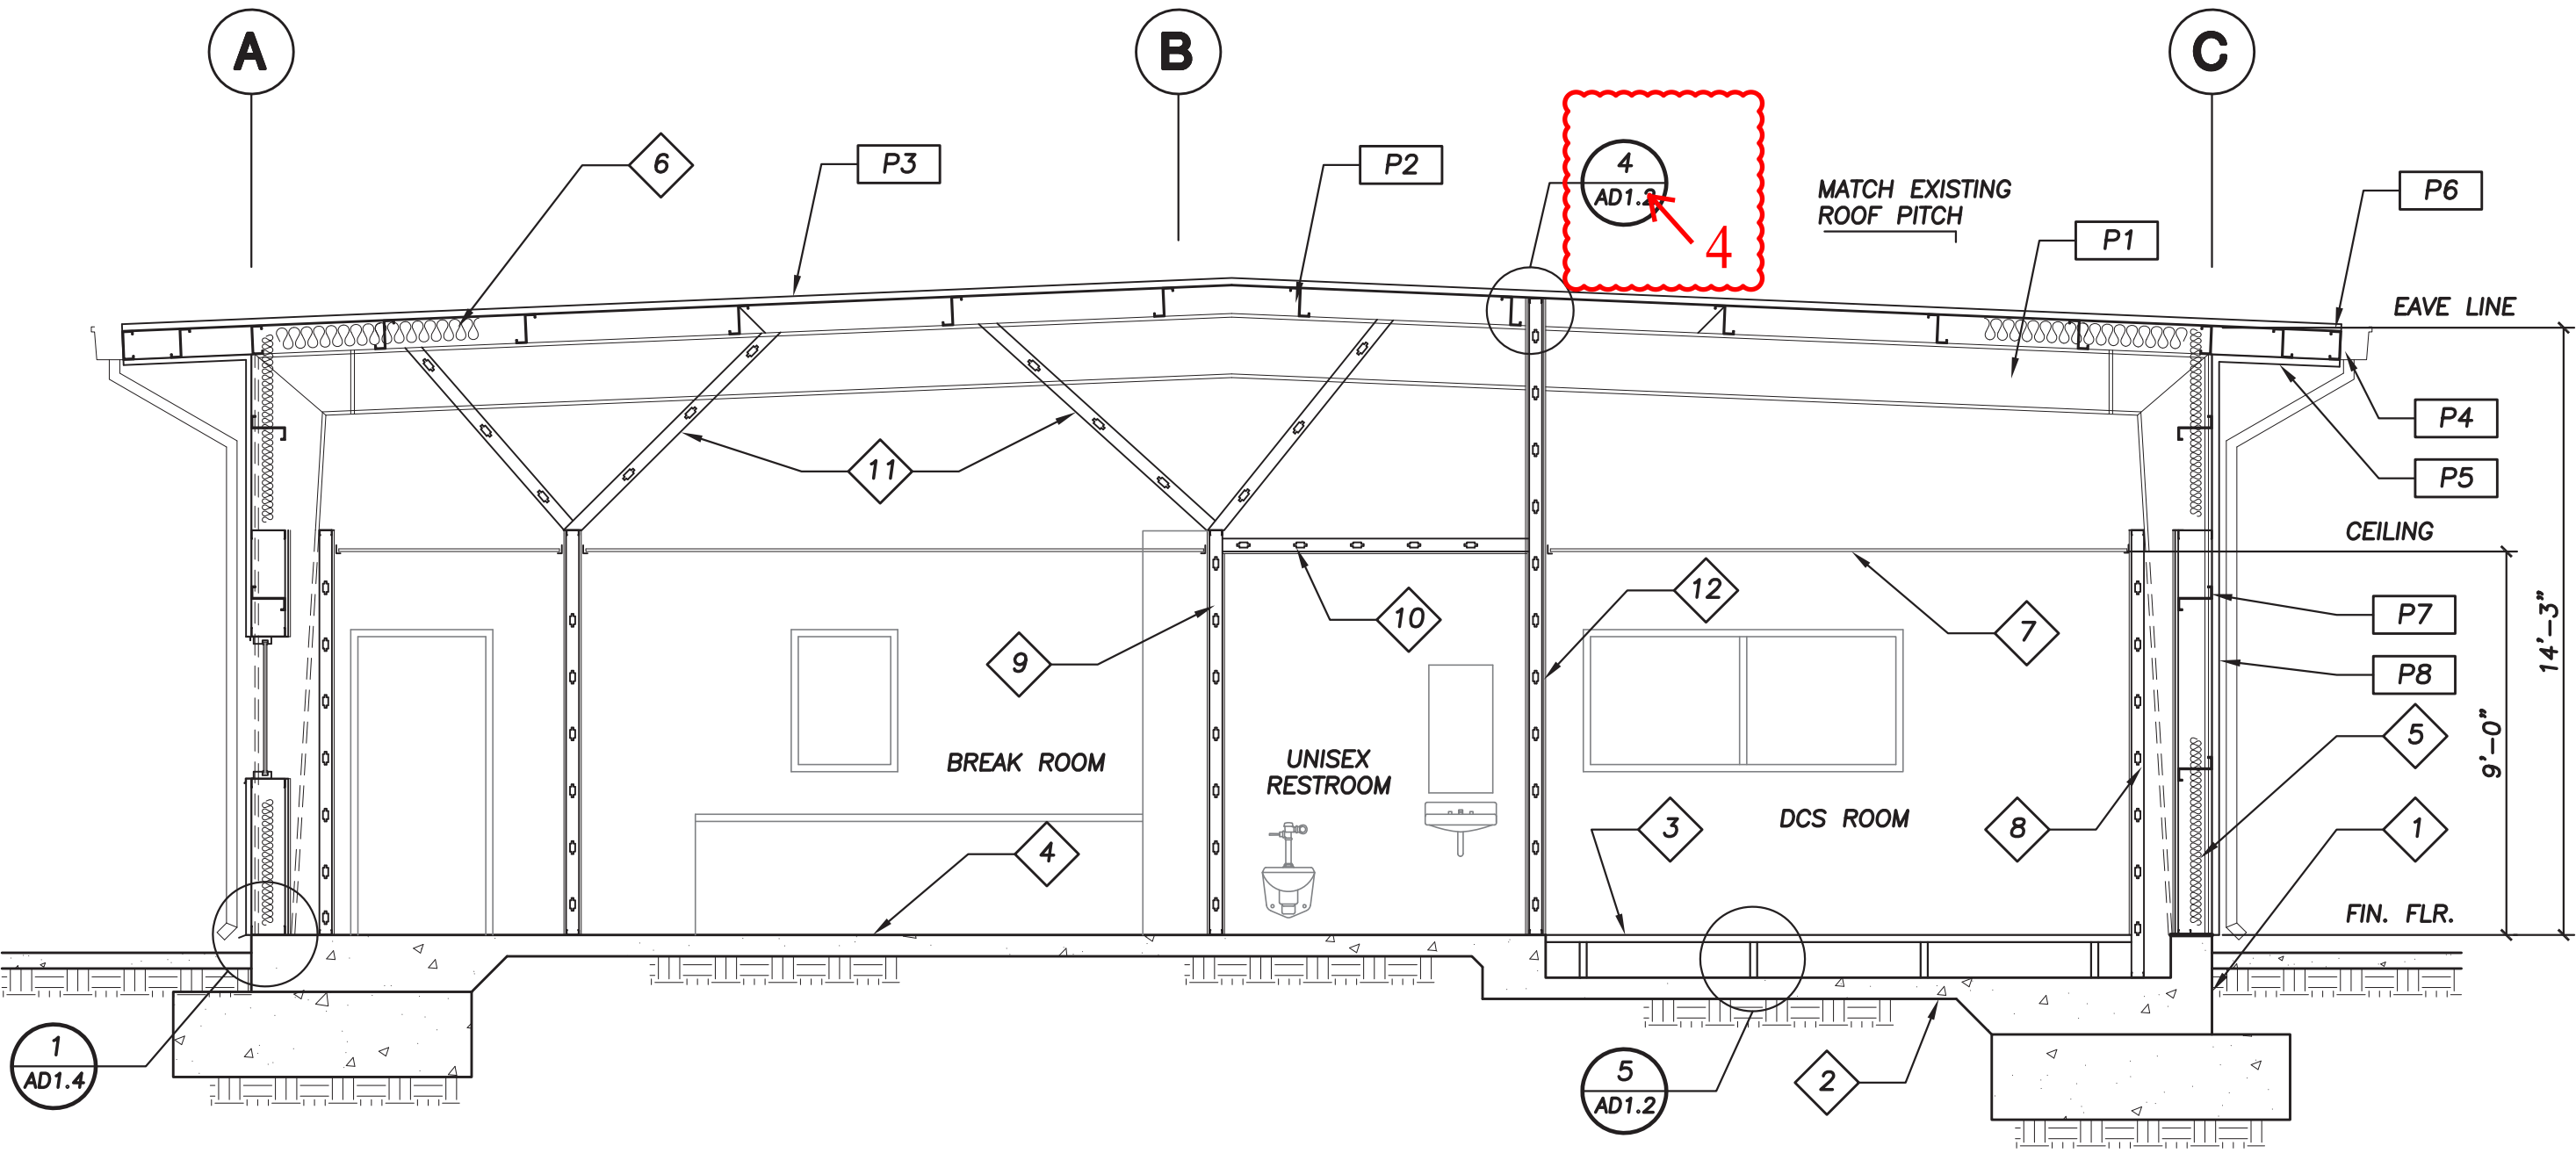


KEYNOTES

- 1 CONCRETE FOOTING PER STRUCTURAL
- 2 RECESSED FLOOR SLAB PER STRUCTURAL
- 3 COMPUTER FLOORING PER FINISH SCHEDULE SEE DETAIL 5/AD1.2
- 4 FLOOR SLAB PER STRUCTURAL
- 5 R-11 INSULATION TYPICAL IN EXTERIOR WALLS PER ENERGY CALCS
- 6 R-30 INSULATION TYPICAL AT ROOF PER ENERGY CALCS
- 7 SUSPENDED T-BAR CEILING PER REFLECTED CEILING PLAN & FINISH SCHEDULE. SEE DETAIL 8/AD1.2
- 8 FURRED COLUMN, SEE DETAIL
- 9 WALL PER FLOOR PLAN & WALL TYPE DETAILS
- 10 METAL CEILING JOISTS PER REFLECTED CEILING PLAN
- 11 DIAGONAL METAL STRUTS
- 12 2 HOUR PARTITION WALL TO UNDERSIDE OF ROOF STRUCTURE SEE WALL TYPES

PEMB KEYNOTES

- P1 STRUCTURAL STEEL FRAME
- P2 ROOF PURLIN
- P3 METAL ROOF PANEL
- P4 METAL EAVE FASCIA & GUTTER
- P5 METAL SOFFIT PANEL
- P6 EAVE STRUT
- P7 WALL GIRT
- P8 EXTERIOR METAL WALL PANEL

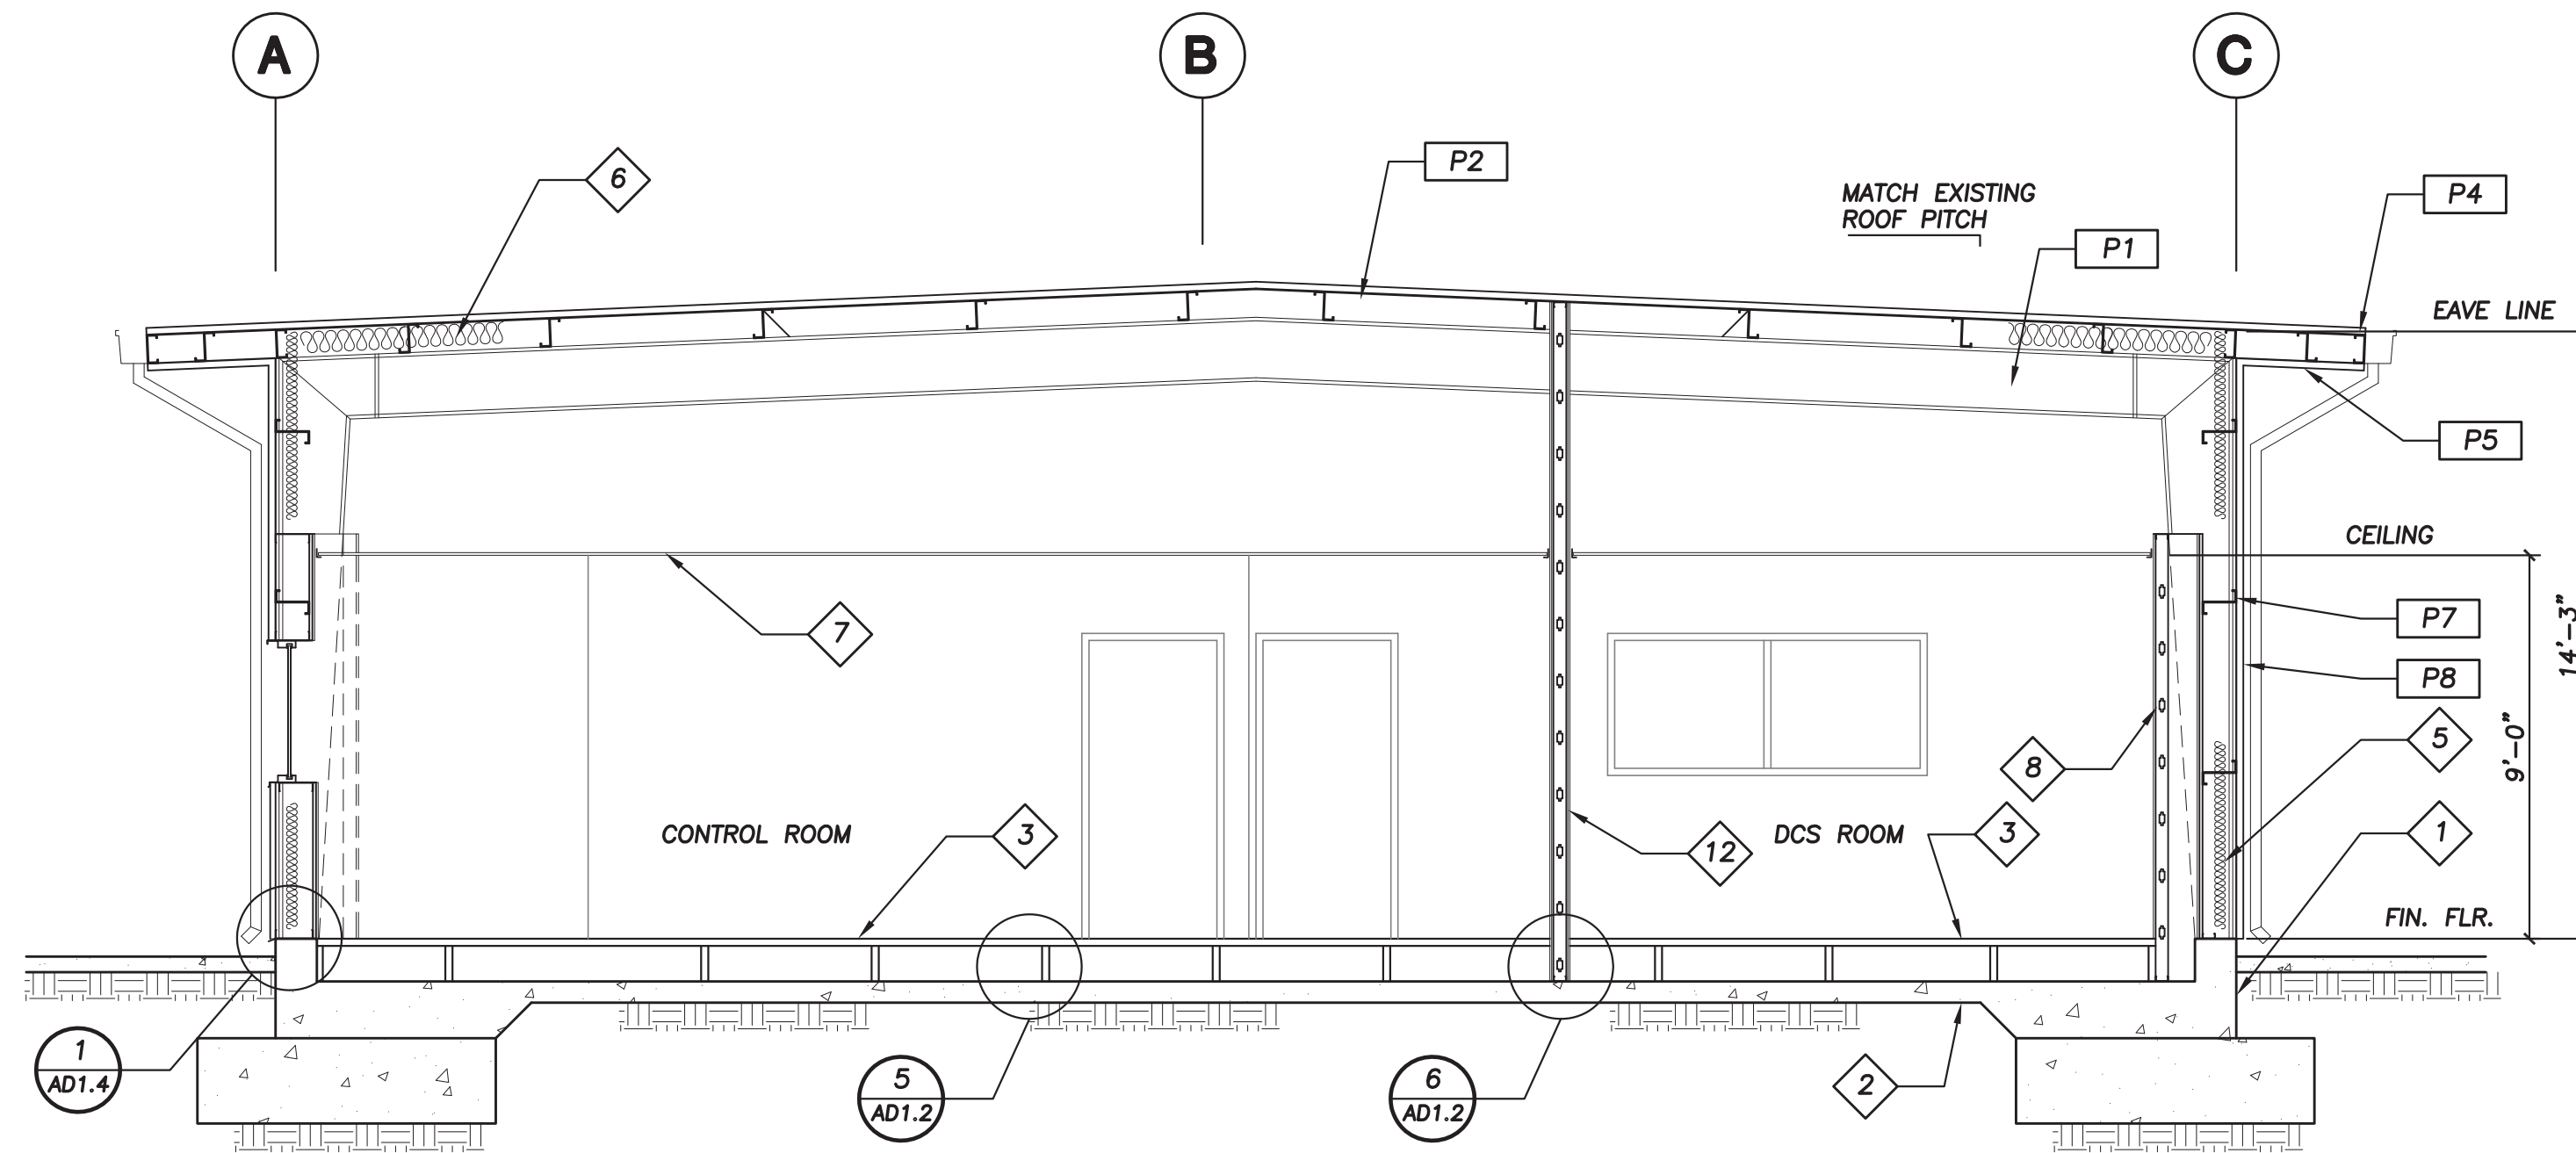

REV	DESCRIPTION	DWN	CHK	APP	DATE
A	100% SUBMITTAL	BP	JM	-	11.30.11

LOS ANGELES
DEPARTMENT OF WATER AND POWER

HAYNES GENERATING STATION
UNITS 11-16

Kiewit Power
9401 Harper Boulevard
Lawrence, Kansas 66219

STRUCTURAL ENGINEERS:
**J. MILCZEWSKY
and ASSOCIATES**
3275 E. DATE ST.
BREA, CA. 92823
(714) 335-1289 BUS
(714) 494-8012 FAX
JOB NUMBER 10-048

CONTROL BUILDING
SECTIONS

DWP DRAWING NUMBER

DESIGNED: —
DRAWN: BAP
CHECKED: JAM
APPROVED: —

DRAWING NUMBER
A6.1